


RENOVATION PROJECT FOR:

Beck Legacy Group Building 200

PRESCOTT , ARIZONA

Area Map

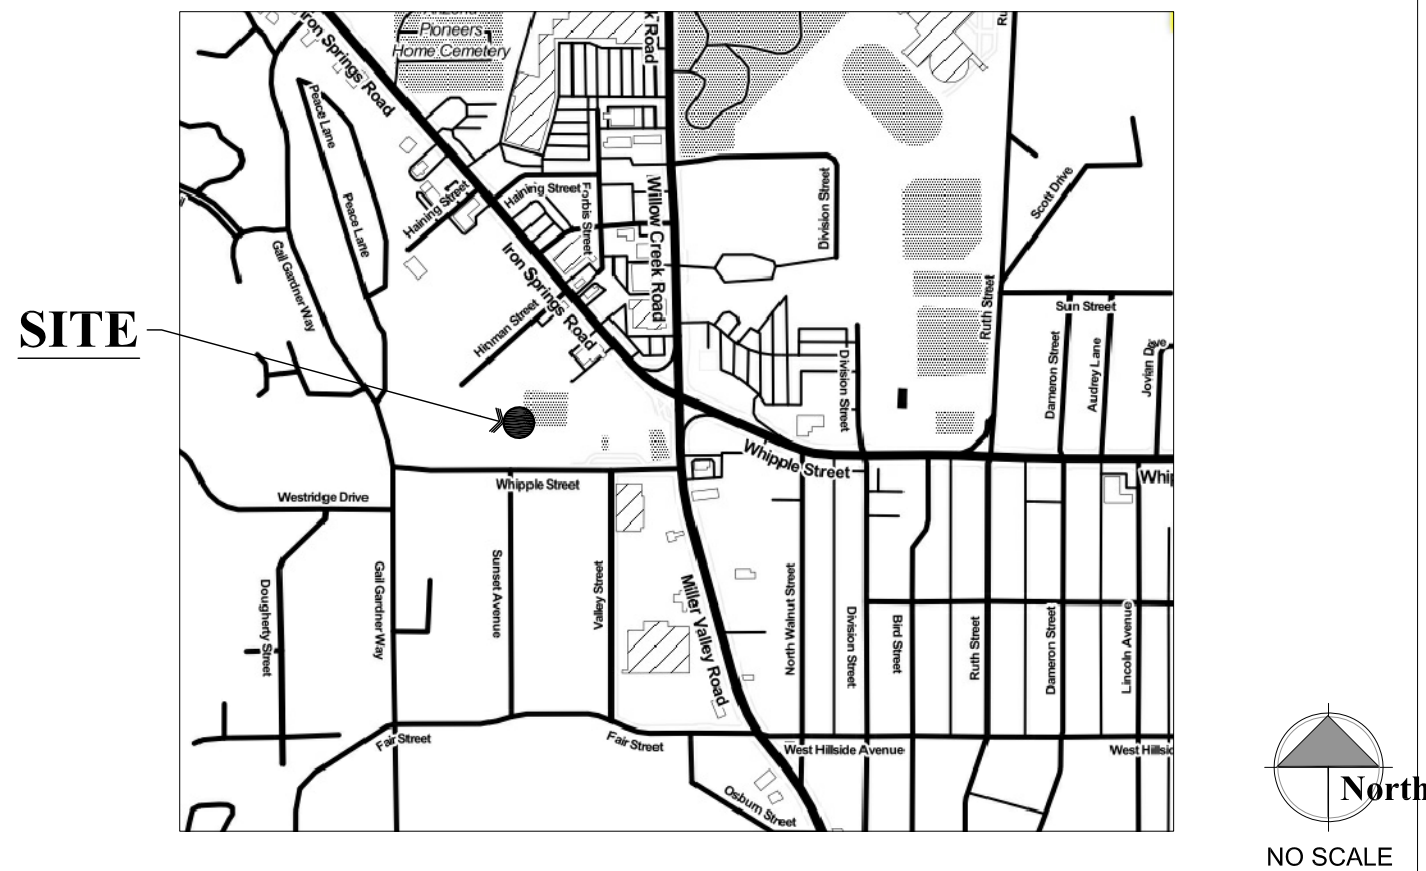


Deferred Submittals

The following items are required and will be provided as a deferred submittal:


1. Automatic Fire Sprinkler System.
2. Fire Alarm System.

Automatic Fire Sprinkler System & Fire Alarm System submittal documents for deferred submittal shall be submitted to the local fire district, who shall review them and forward them to the building official, with a notation indicating that the deferred submittal documents have been reviewed and that they have been found to be in general conformance with the design of the building. The deferred submittal items shall "NOT" be installed until their design and submittal documents have been approved by the fire marshal having jurisdiction.

Vicinity Map

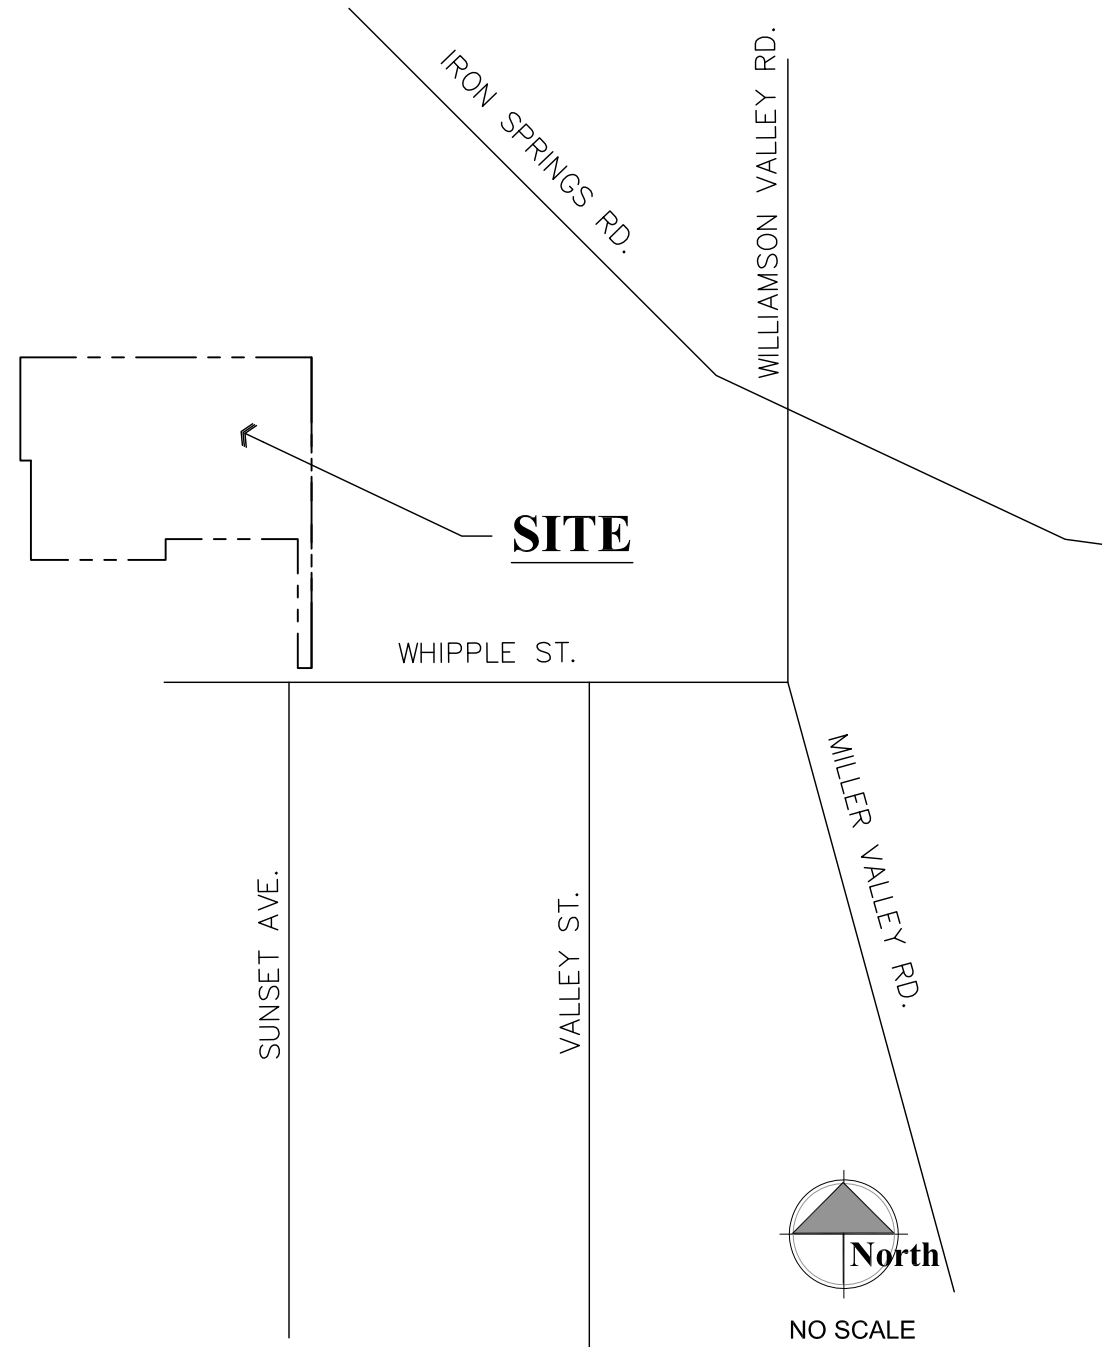

Graphic Standards

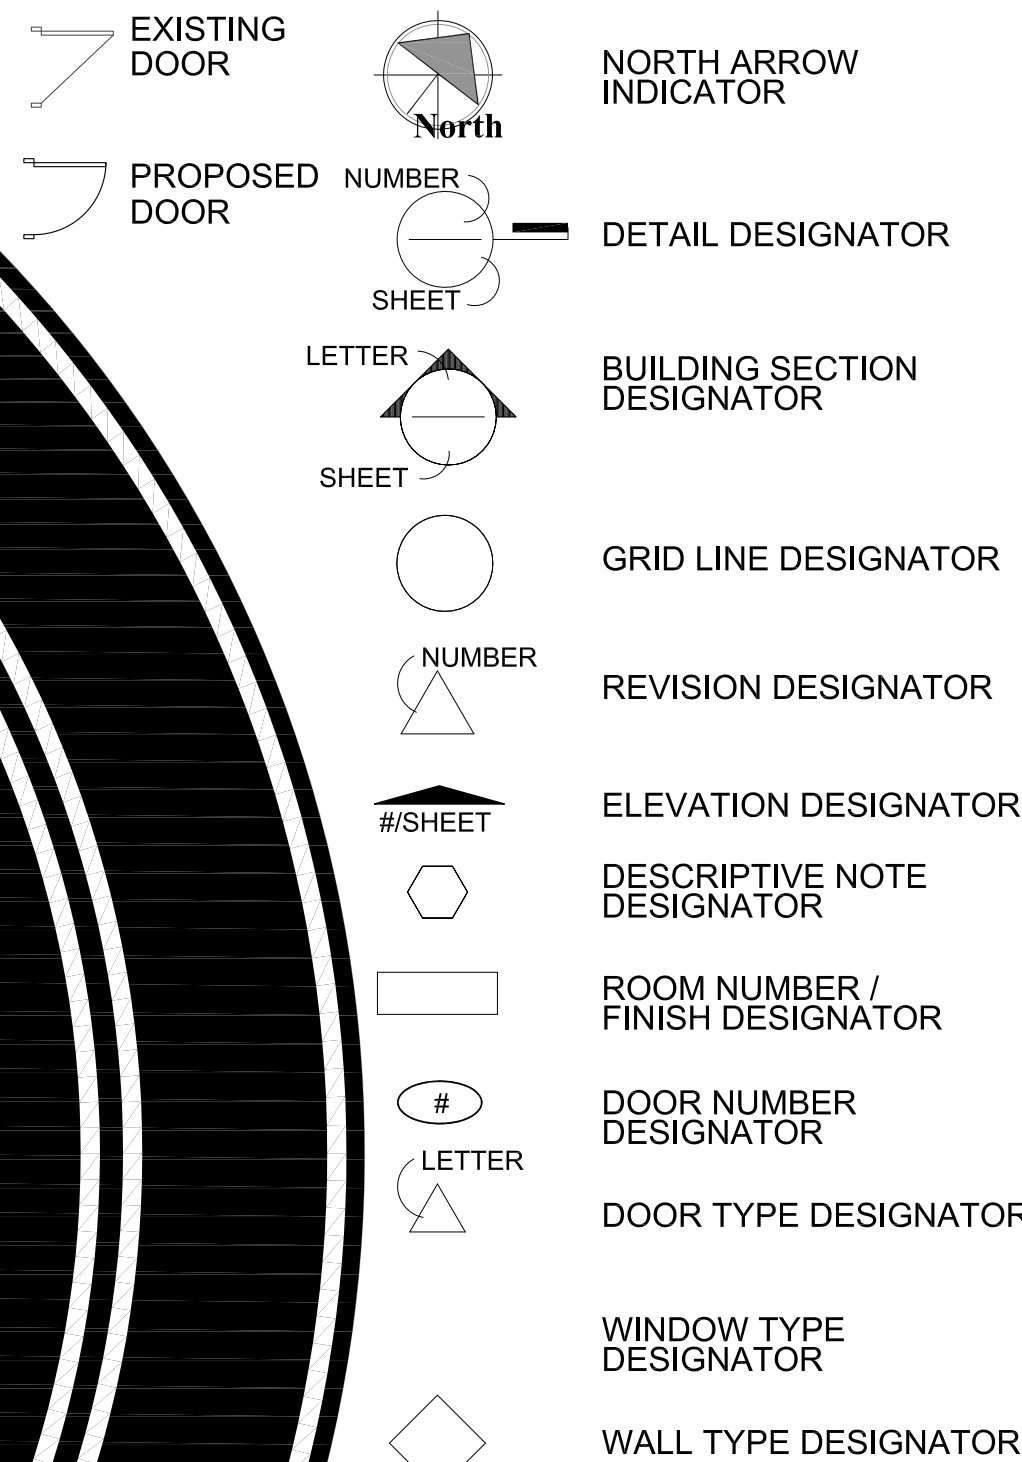

Project Information

OWNER	Beck Legacy Group
PREPARED BY:	W. Alan Kenson & Associates, P.C. P.O. Box 11593 Prescott, AZ 86304
CONTRACTOR:	Kenson Construction Company Inc. 6135 Corsair Avenue Prescott, AZ 86301
SCOPE OF WORK:	Building Remodel
PROJECT ADDRESS:	1040 Whipple St. Prescott, AZ 86305
PARCEL #	115-09-008C
ZONE	BR
OCCUPANCY:	R-2
CONSTRUCTION TYPE:	II-B (sprinklered)
ALLOWABLE AREA:	23,000 +200% = 69,000 S.F.
ACTUAL AREA:	14,120 S.F. (Lower level: 7,060 Upper level: 7,060)
EMERGENCY LIGHTING:	Yes
FIRE ALARMS:	Yes
FIRE SPRINKLERS:	Yes
BUILDING CODE:	2012 International Building Code

PARKING REQUIRED

Residential 1 per studio plus max 20 visitors
1 per bed in dorms
Total spaces required: 150 for buildings 200 and 300
Provided: 129

Sheet Index

ARCHITECTURAL	
CS1	COVER SHEET
CS2	PRELIMINARY CODE COMPLIANCE / EXITING / OCCUPANCY FLOOR PLAN
A1.0	PRELIMINARY ARCHITECTURAL / PARTIAL UTILITIES SITE PLAN
A2.0	PRELIMINARY ARCHITECTURAL DEMOLITION FLOOR PLANS
A3.0	PRELIMINARY ARCHITECTURAL REFERENCE FLOOR PLANS
A4.0	PRELIMINARY ARCHITECTURAL DIMENSION FLOOR PLANS
A5.0	PRELIMINARY FURNITURE PLANS
A6.0	PRELIMINARY BUILDING SECTIONS
A7.0	PRELIMINARY EXTERIOR ELEVATIONS
A8.0	PRELIMINARY DOOR SCHEDULE, MATERIAL SCHEDULE AND FLOOR FINISH PLAN
A9.0	PRELIMINARY ENLARGED PLANS AND INTERIOR ELEVATIONS
ELECTRICAL	
E1.0	PRELIMINARY ELECTRICAL PLANS

Project Description

THE OWNER'S PROPOSED DEVELOPMENT INCLUDES TWO BUILDING REMODELS. THE BUILDINGS CURRENTLY ARE USED FOR COMMERCIAL OFFICES. BUILDING 200 WILL BE REMODELED TO HOUSE 44 STUDIO APARTMENTS AND BUILDING 300 WILL INCLUDE 14 DORM STYLE UNITS AND 30 STUDIO APARTMENTS. PTAC HVAC UNITS WILL BE PROVIDED FOR EACH APARTMENT UNIT UNDER THE WINDOW, AND A WATER HEATING SYSTEM FOR ALL OF THE UNITS WILL BE HOUSED IN A MECHANICAL ROOM AND DISTRIBUTED FROM THERE. THE SITE UTILITIES WILL BE MODIFIED TO ACCOMMODATE THE BUILDING'S NEW USE.

Architect:

W. Alan Kenson & Associates, P.C.

P 928-443-5812 P.O. Box 11593
F 928-443-5815 Prescott, AZ 86304

email: waka@cableone.net
www.kenson-associates.com

ARCHITECTURE & PLANNING



W. Alan Kenson & Associates, P.C.

P 928-443-5812 P.O. Box 11593
F 928-443-5815 Prescott, AZ 86304
email: waka@cableone.net
www.kenson-associates.com
ARCHITECTURE & PLANNING

DRAWING: Cover Sheet

PROJECT: Renovation Project for Beck Legacy Group
1040 Whipple Street Building 200
Prescott, AZ 86305

APN: 115-09-008D

DRAWN BY	L.O.
CHECKED BY	W.A.K.
DATE	April 5th, 2018
JOB NO.	711
SHEET	


CS


REVISIONS	BY

These drawings are the property of W. Alan Kenson & Associates P.C., and may not be reproduced in any way without the written consent of W. Alan Kenson & Associates, P.C.


PRELIMINARY NOT FOR CONSTRUCTION

Apr 05, 2018 - 2:45pm

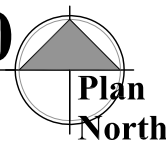A1 Occupancy / Egress 1st Floor Plan B200
Scale: 1/8"=1'-0" 

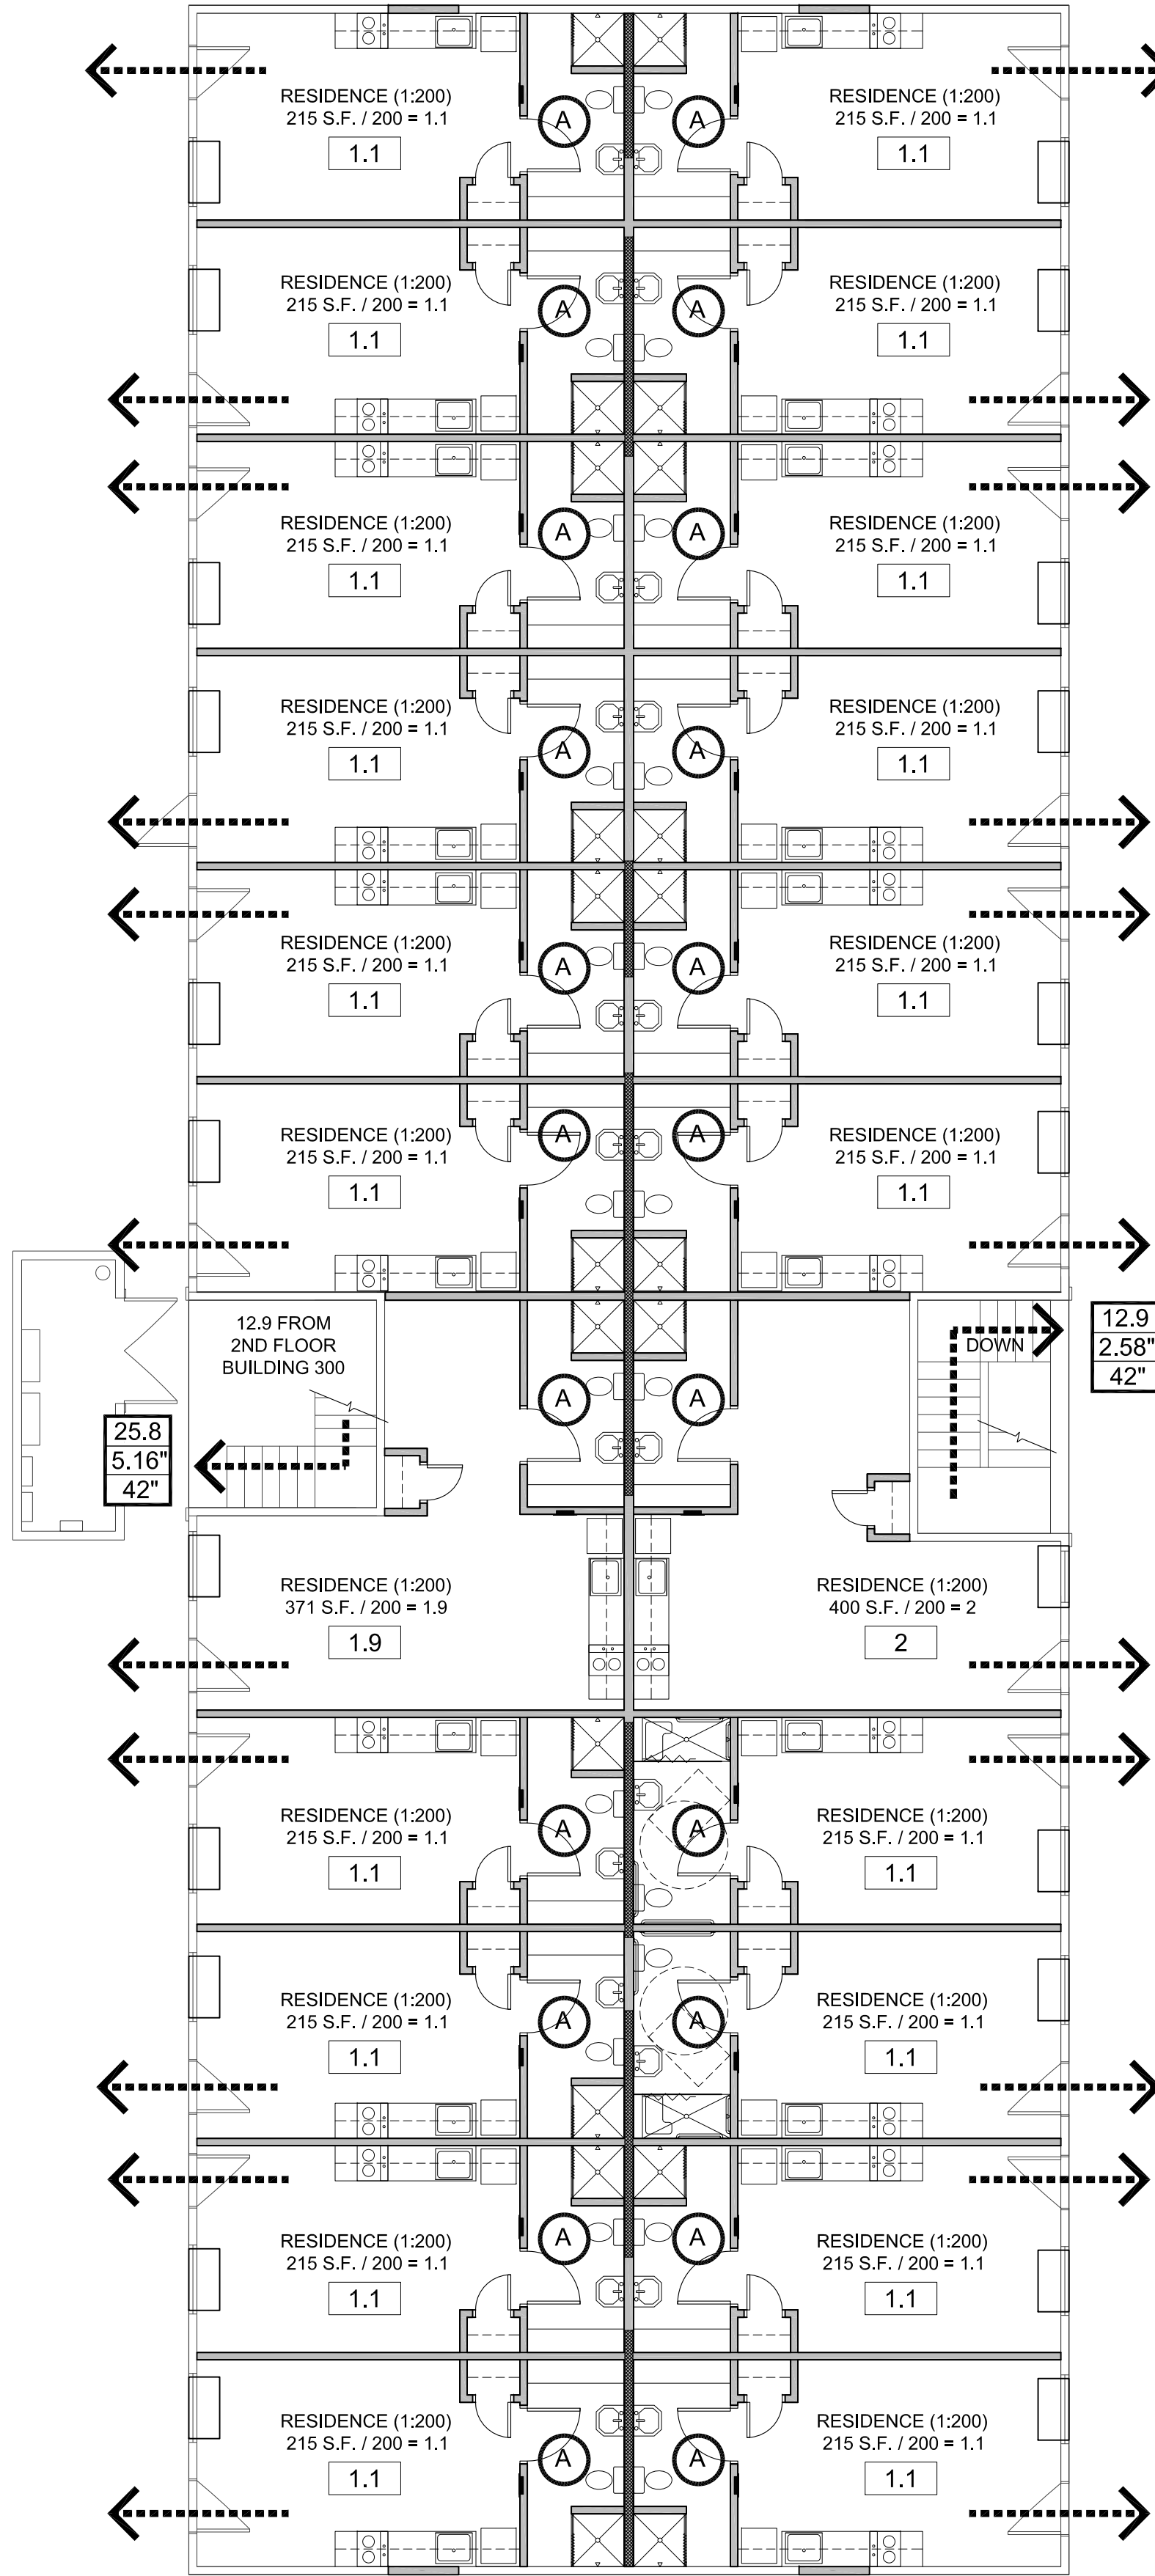

B1 Occupancy / Egress 2nd Floor Plan B200
Scale: 1/8"=1'-0" 

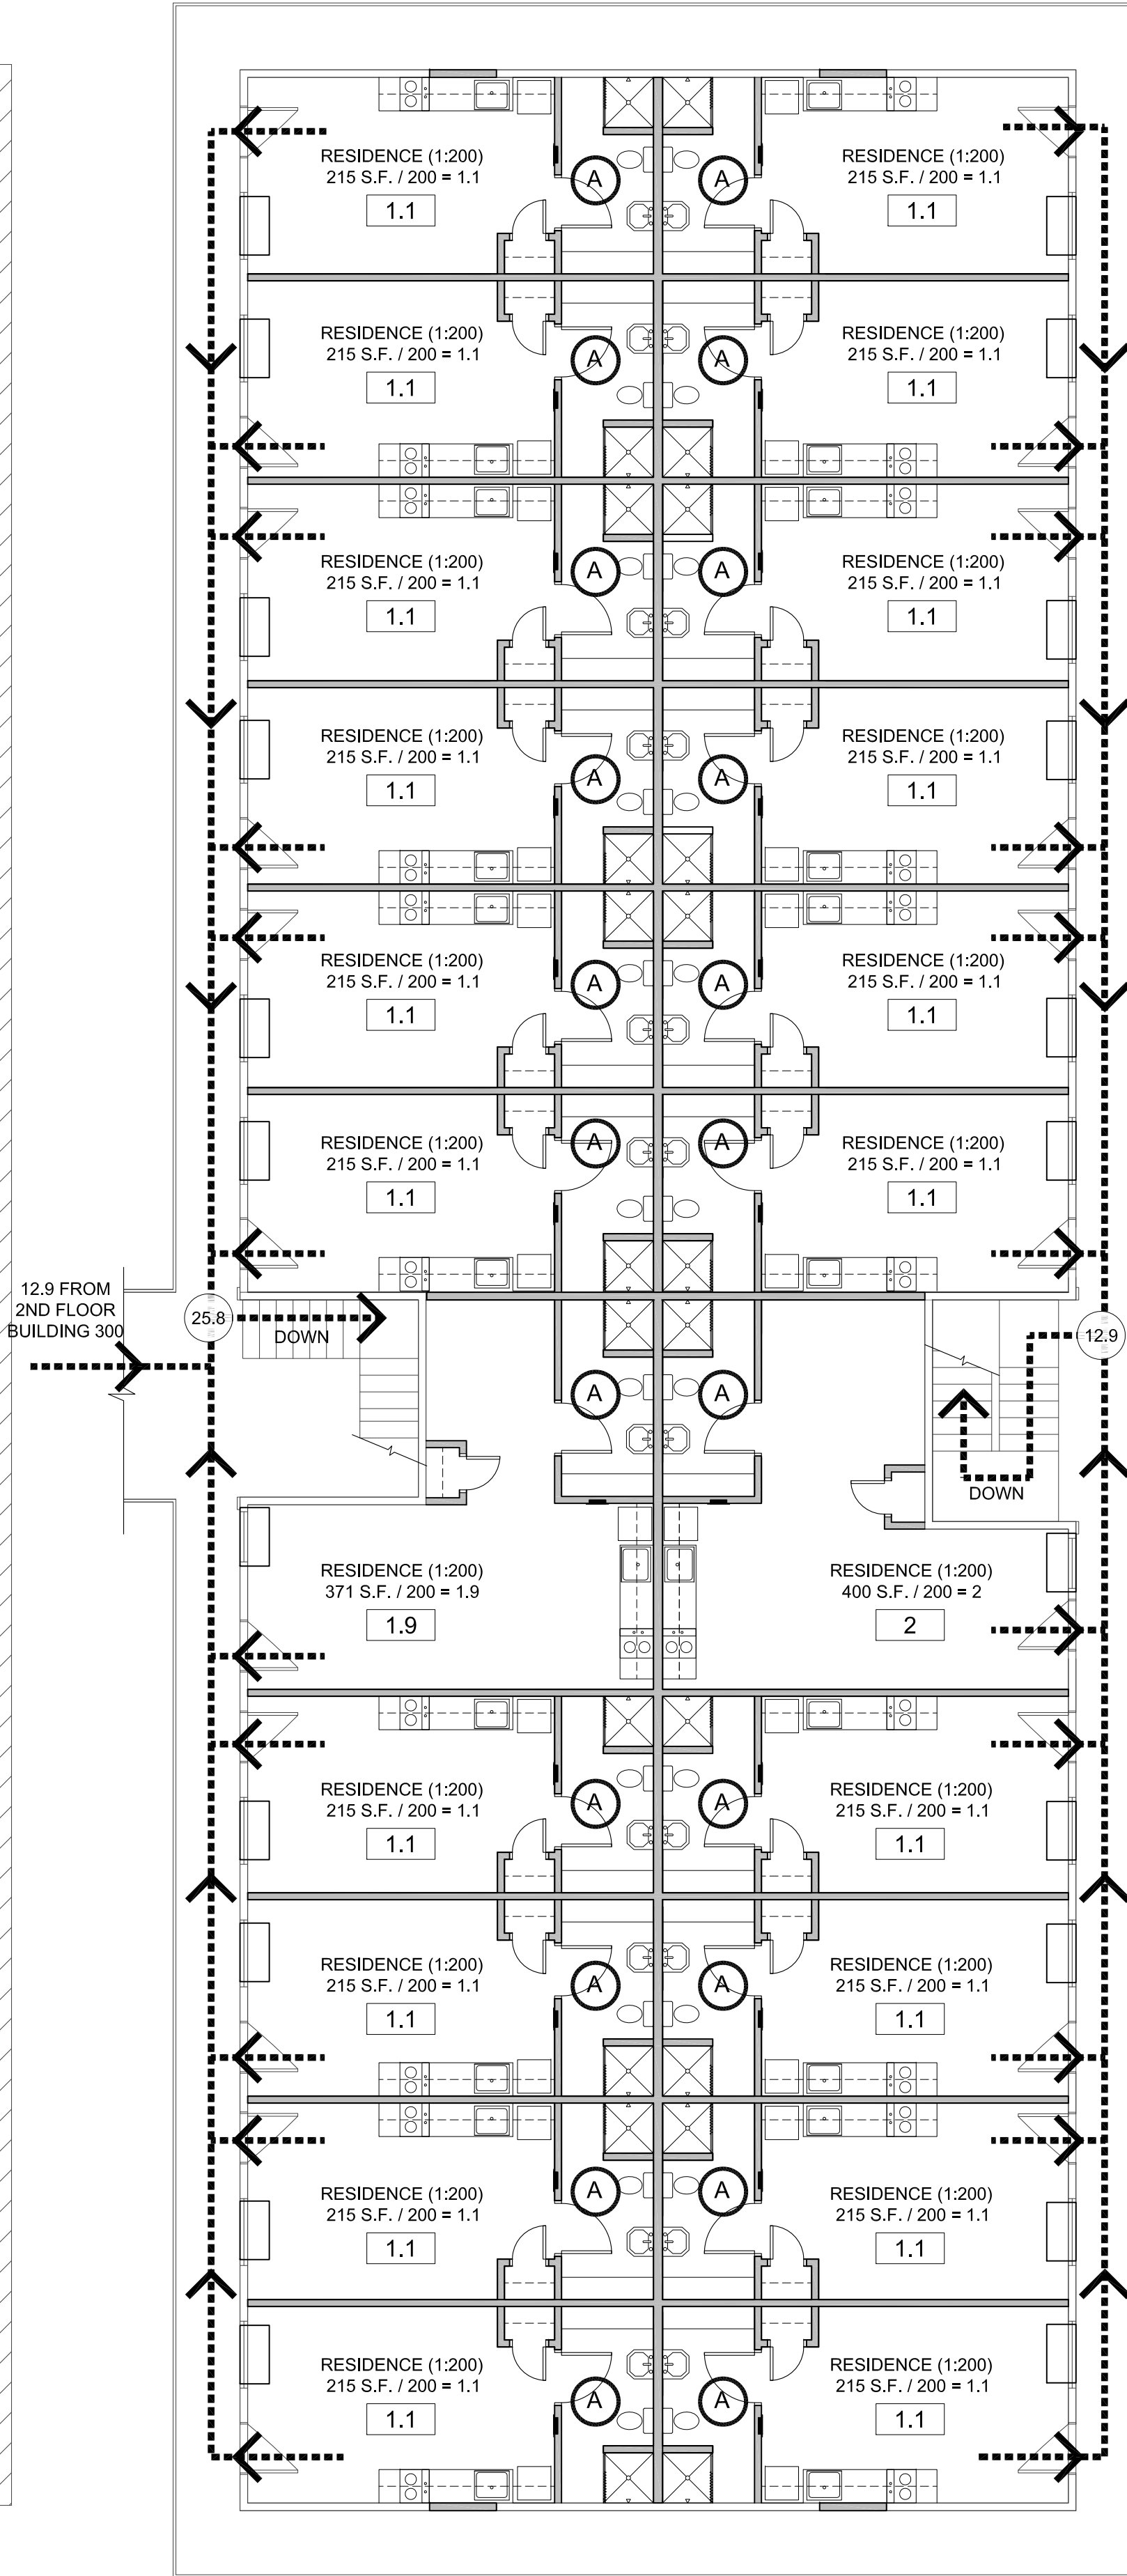

Accessibility Notes

- ACCESS TO THESE FACILITIES SHALL BE AT PRIMARY ENTRANCES.
- THE SLOPE OF PUBLIC WALKS SHALL NOT EXCEED A MAXIMUM CROSS SLOPE OF 2%.
- WALKING SURFACES GREATER THAN 2% SHALL BE SLIP RESISTANT.
- PROVIDE A 44"x60" MINIMUM LANDING ON THE STRIKE SIDE OF THE ENTRANCE DOOR WITH 44" MINIMUM WIDTH IN THE DIRECTION OF TRAVEL.
- WALLS SHALL EXTEND 18" TO THE SIDE OF THE STRIKE EDGE OF A DOOR OR GATE THAT SWINGS TOWARDS THE OCCUPANT.
- RAMPS SHALL HAVE A NON-SLIP SURFACE.
- RAMPS SHALL BE A MINIMUM OF 36" WIDE.
- EVERY REQUIRED EXIT DOORWAY SHALL BE SIZED FOR A DOOR NOT LESS THAN 36" WIDE BY NOT LESS THAN 6'-8" HIGH CAPABLE OF OPENING 90 DEGREES AND MOUNTED SO THE CLEAR WIDTH OF THE EXIT WAY IS 32" MINIMUM.
- THRESHOLDS TO BE A MAXIMUM OF 1/4" ABOVE ADJACENT FLOOR FINISH. ONE-HALF INCH THRESHOLD MAY BE USED IF BEVELED PER A.D.A. STANDARDS.
- MAXIMUM EFFORT TO OPERATE A DOOR SHALL NOT EXCEED 5 POUNDS.
- THE BOTTOM 10 INCHES OF ALL DOORS EXCEPT AUTOMATIC AND SLIDING DOORS SHALL HAVE A SMOOTH UNINTERRUPTED SURFACE.
- PROVIDE LEVER TYPE HARDWARE, PANIC BARS, PUSH AND PULL ACTIVATING BARS, OR OTHER HARDWARE DESIGNED TO PROVIDE PASSAGE WITHOUT REQUIRING THE ABILITY TO GRASP THE OPENING HARDWARE. (30" TO 44" A.F.F.)

Egress Legend:

	EXIT ACCESS
	ACCESSORY USE (NO OCCUPANCY)
	ROOM OCCUPANCY LOAD
	SUBTOTAL OCCUPANCY LOAD
	OCCUPANCY TOTAL
	REQUIRED EXIT WIDTH (FACTOR = 0.2)
	PROVIDED EXIT WIDTH
	WORST CASE TRAVEL DISTANCE
FUNCTION OF SPACE	OCCUPANT LOAD FACTOR
RESIDENCE	200 GROSS

Occupant load

NOTE:
GROSS SQUARE FOOTAGE LISTED BELOW
DOES NOT INCLUDE ACCESSORY AREAS.

RESIDENCE: 10,142 SQ. FT. 51 OCCUPANTS
TOTAL: 10,142 SQ. FT. 51 OCCUPANTS

REVISIONS	BY

These drawings are the property of W. Alan Kenson & Associates P.C., and may not be reproduced in any way without the written consent of W. Alan Kenson & Associates, P.C.

PRELIMINARY NOT
FOR CONSTRUCTION

W. Alan Kenson & Associates, P.C.



P 928-443-5812
F 928-443-5815
email: waka@cableone.net
www.kenson-associates.com

ARCHITECTURE & PLANNING

DRAWING: Preliminary Code Compliance / Exiting / Occupancy Floor Plans


PROJECT: Renovation Project for Beck Legacy Group
1040 Whipple Street Building 200
Prescott, AZ 86305

APN: 115-09-008D

DRAWN BY L.O.
CHECKED BY W.A.K.
DATE April 5th, 2018
JOB NO. 711
SHEET

CS2

Apr 05, 2018 - 2:46pm

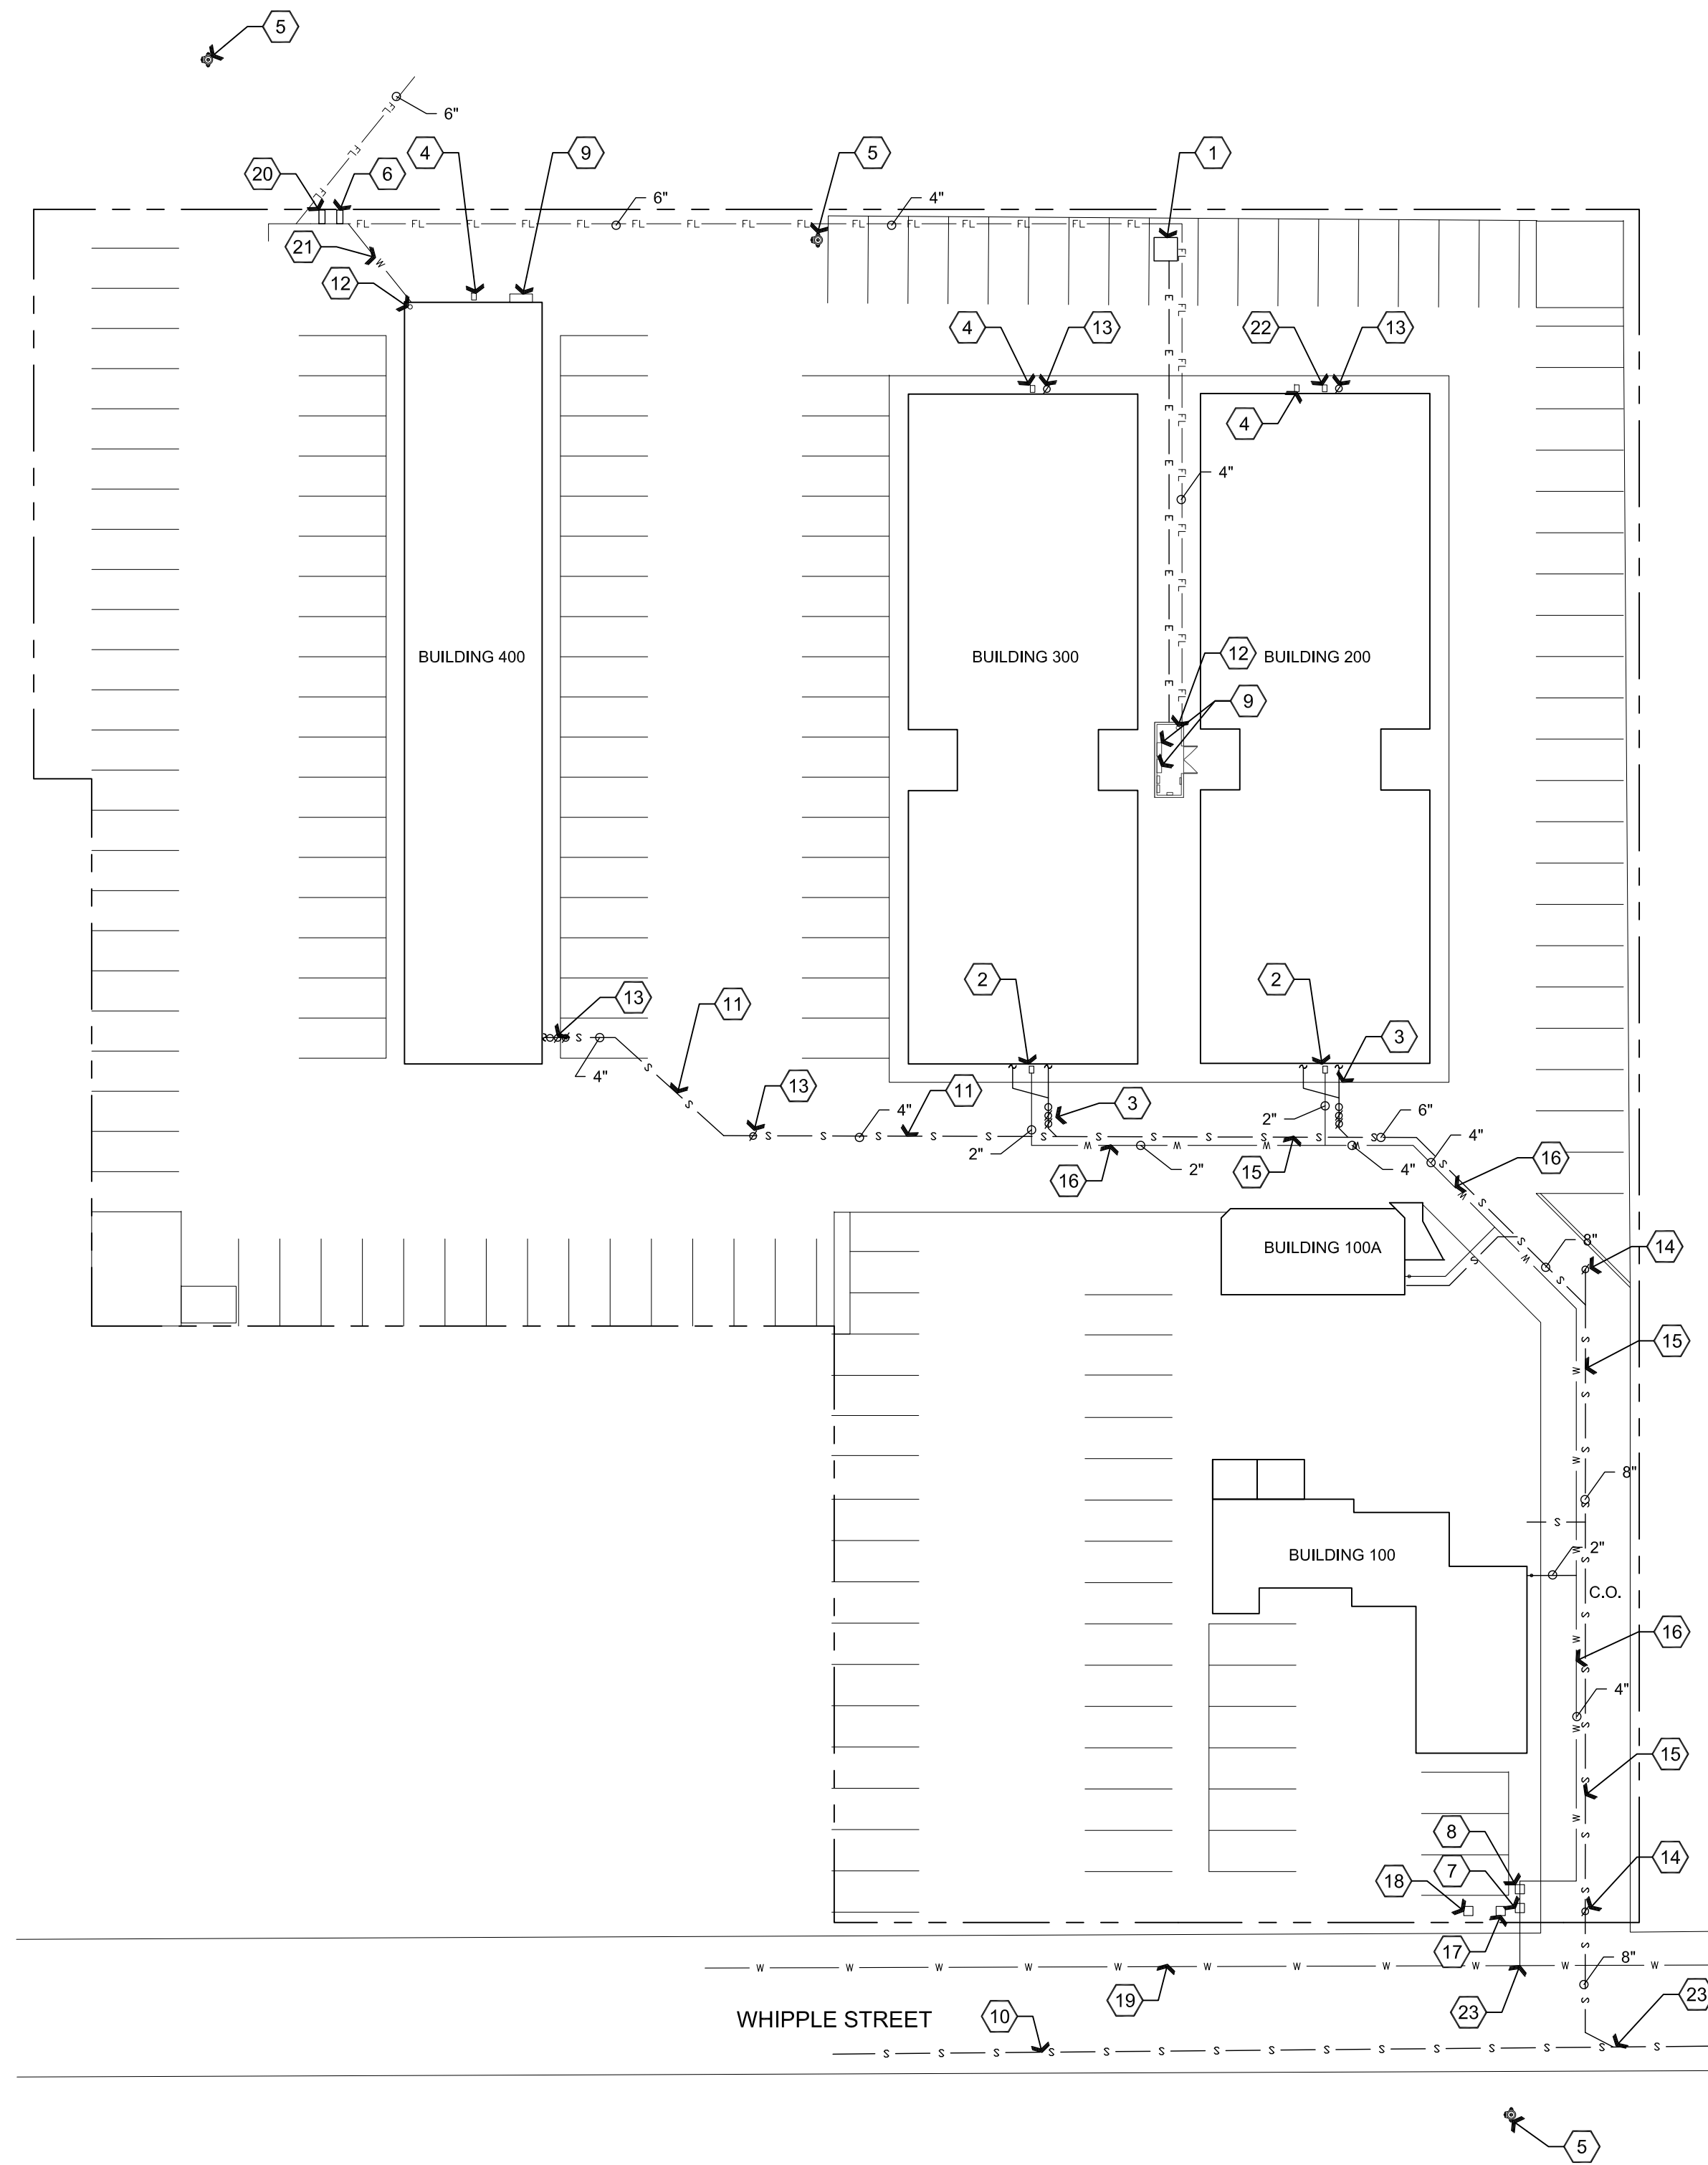

Descriptive Keynotes

1. EXISTING ELECTRICAL TRANSFORMER.
2. PROPOSED 2" WATER SHUT OFF VALVE.
3. PROPOSED 6" BACKWATER VALVE AND 2 WAY SEWER CLEAN OUT.
4. EXISTING NATURAL GAS METER / REGULATOR.
5. EXISTING FIRE HYDRANT.
6. EXISTING 3/4" DOMESTIC REDUCED PRESSURE BACKFLOW PREVENTION DEVICE.
7. PROPOSED 3" CITY WATER METER.
8. PROPOSED 4" REDUCED PRESSURE BACKFLOW PREVENTION DEVICE IN ASSE INSULATED ENCLOSURE.
9. EXISTING 1200 AMP, 120/208, 3 PHASE ELECTRIC SERVICE ENTRANCE SECTION.
10. EXISTING CITY OF PRESCOTT 12" SEWER MAIN.
11. EXISTING 4" SEWER.
12. EXISTING 4" FIRE RISER.
13. EXISTING 4" SEWER CLEAN OUT.
14. PROVIDE 8" SEWER CLEAN OUT.
15. NEW SEWER LINE SIZE AS INDICATED. SAWCUT EXISTING CONCRETE DRIVEWAY. EXCAVATE AND REPLACE IN KIND.
16. NEW WATER LINE SIZE AS INDICATED. SAWCUT EXISTING CONCRETE DRIVEWAY. EXCAVATE AND REPLACE IN KIND.
17. EXISTING 5/8" METER TO BE ABANDONED (PROBABLY BLDG 200 AND 300).
18. EXISTING 5/8" METER FOR BUILDING 100 AND 100A TO BE ABANDONED.
19. EXISTING CITY OF PRESCOTT WATER MAIN.
20. 5/8" DOMESTIC WATER METER FOR BUILDING 400.
21. EXISTING WATER LINE SIZE UNKNOWN.
22. EXISTING WATER SHUT OFF VALVE.
23. POINT OF ATTACHMENT.

REVISIONS	BY

These drawings are the property of
W. Alan Kenson & Associates P.C.,
and may not be reproduced in any
way without the written consent of
W. Alan Kenson & Associates, P.C.

PRELIMINARY NOT
FOR CONSTRUCTION

W. Alan Kenson & Associates, P.C.



P 928-443-5812 P.O. Box 11593
F 928-443-5815 Prescott, AZ 86304
email: waka@cableone.net
www.kenson-associates.com

ARCHITECTURE & PLANNING

DRAWING: Preliminary Architectural / Utilities Site Plan

PROJECT: Renovation Project for Beck Legacy Group
1040 Whipple Street Building 200
Prescott, AZ 86305

APN: 115-09-008D

DRAWN BY
L.O.

CHECKED BY
W.A.K.

DATE
April 5th, 2018

JOB NO.
711

SHEET

A1.0




Preliminary Architectural Utilities / Site Plan

Scale: 1"=30'-0"




Apr 05, 2018 - 2:46pm

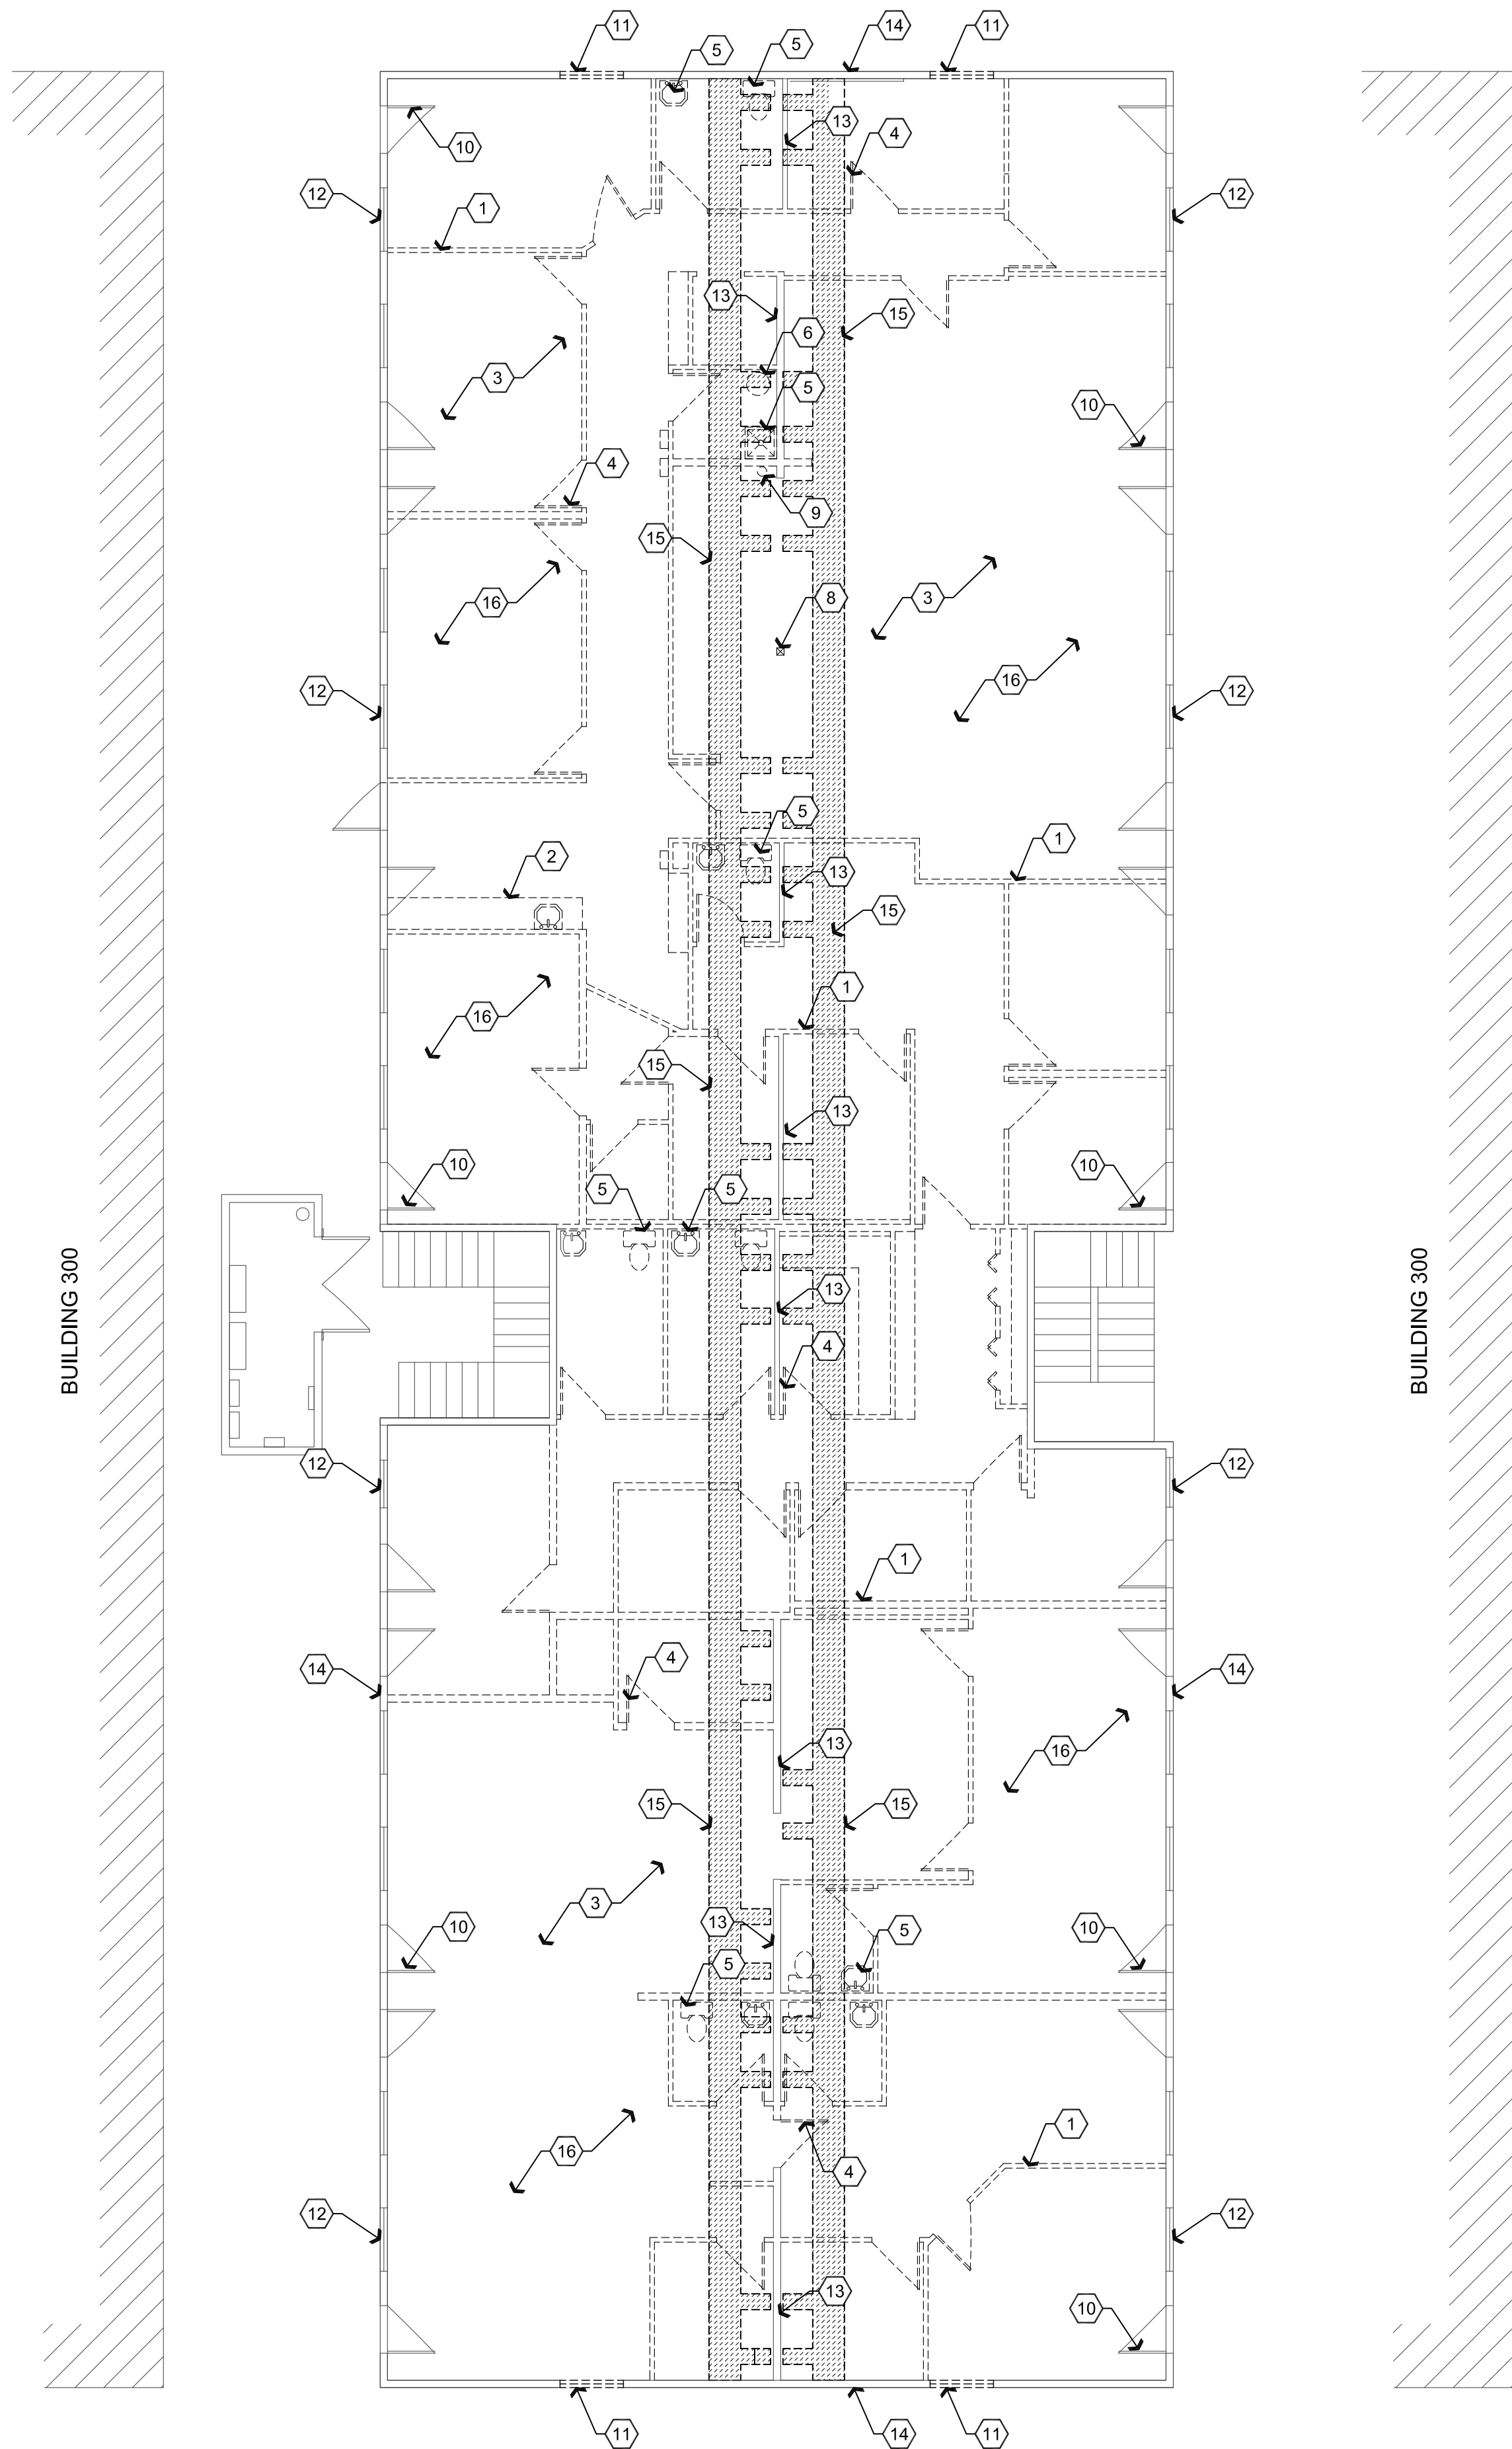

Demolition 1st Floor Plan B200

Scale: 1/8"=1'-0"

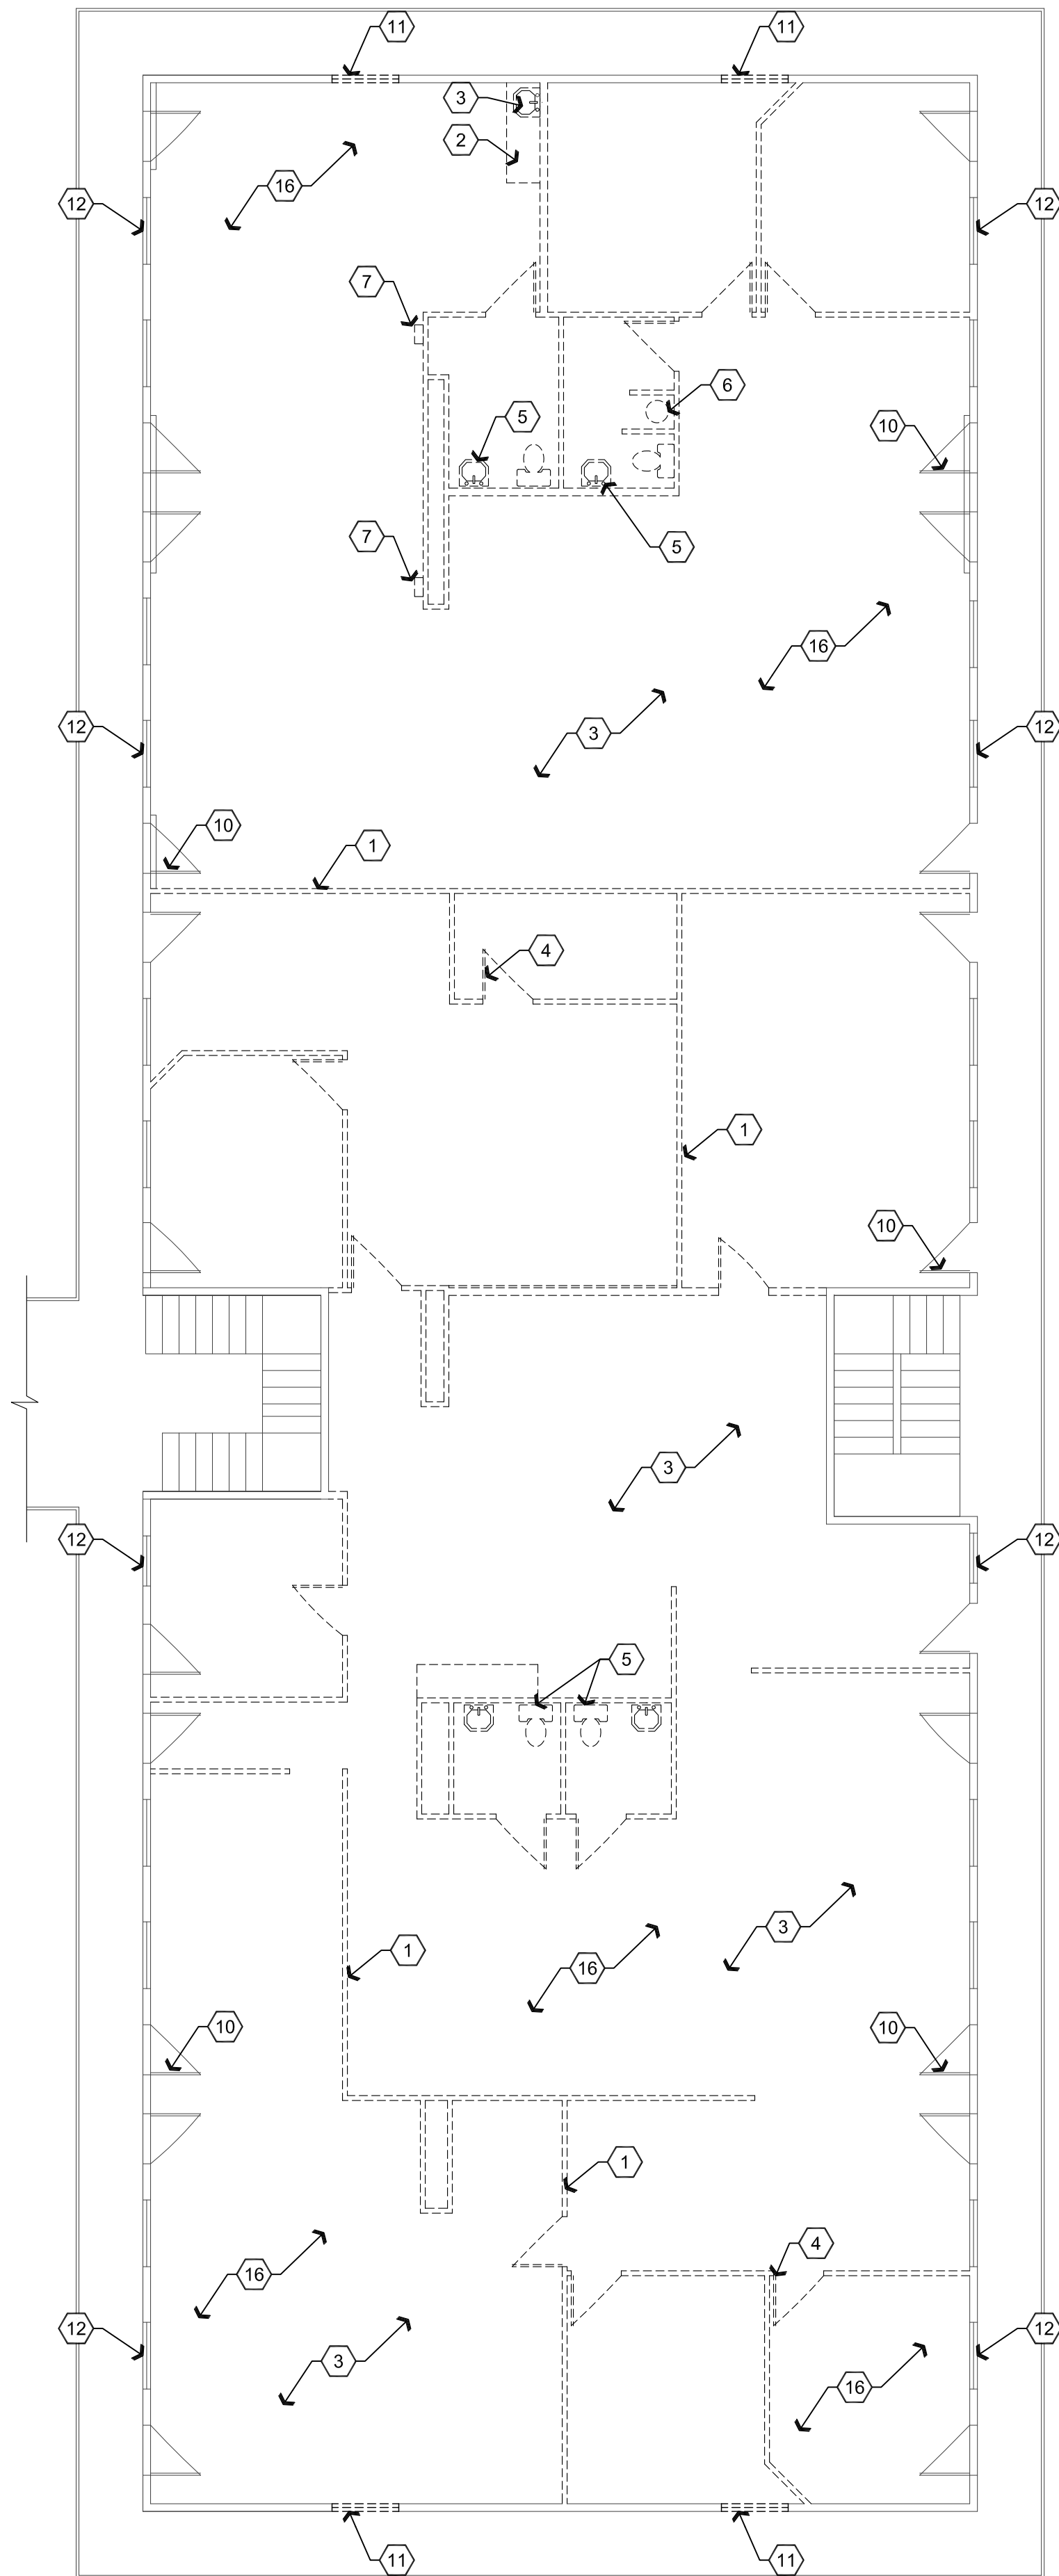

Demolition 2nd Floor Plan B200

Scale: 1/8"=1'-0"



Descriptive Keynotes

1. REMOVE EXISTING INTERIOR WALL, TYPICAL.
2. REMOVE EXISTING CASEWORK, TYPICAL.
3. REMOVE EXISTING FLOORING, TYPICAL.
4. REMOVE EXISTING INTERIOR DOOR AND FRAME, TYPICAL.
5. REMOVE EXISTING PLUMBING FIXTURES, TYP.
6. REMOVE EXISTING WATER HEATER.
7. REMOVE EXISTING ELECTRICAL PANEL, TYPICAL.
8. EXISTING COLUMN.
9. EXISTING 4" SEWER CLEANOUT.
10. EXISTING EXTERIOR DOOR AND FRAME TO REMAIN, TYPICAL.
11. REMOVE EXISTING WINDOWS ON NORTH AND SOUTH ENDS OF THE BUILDING, TO BE INFILLED.
12. EXISTING WINDOW TO REMAIN, TYPICAL.
13. EXISTING LOAD BEARING WALL TO REMAIN, TYPICAL.
14. EXISTING EXTERIOR WALL TO REMAIN, TYPICAL.
15. SAWCUT AND REMOVE 2'-0" WIDE PORTION OF CONCRETE SLAB FOR PROPOSED PLUMBING, REFER TO PLUMBING PLANS.
16. REMOVE EXISTING GRID CEILING, FIXTURES ETC., TYPICAL.

REVISIONS	BY

These drawings are the property of W. Alan Kenson & Associates P.C., and may not be reproduced in any way without the written consent of W. Alan Kenson & Associates, P.C.

PRELIMINARY NOT FOR CONSTRUCTION

W. Alan Kenson & Associates, P.C.



P 928-443-5812 P.O. Box 11593
F 928-443-5815 Prescott, AZ 86304
email: waka@cableone.net
www.kenson-associates.com

ARCHITECTURE & PLANNING

DRAWING: Preliminary Architectural Demolition Floor Plan


PROJECT: Renovation Project for Beck Legacy Group
1040 Whipple Street Building 200
Prescott, AZ 86305

115-09-008D

APN:

DRAWN BY L.O.
CHECKED BY W.A.K.
DATE April 5th, 2018
JOB NO. 711
SHEET

A2.0

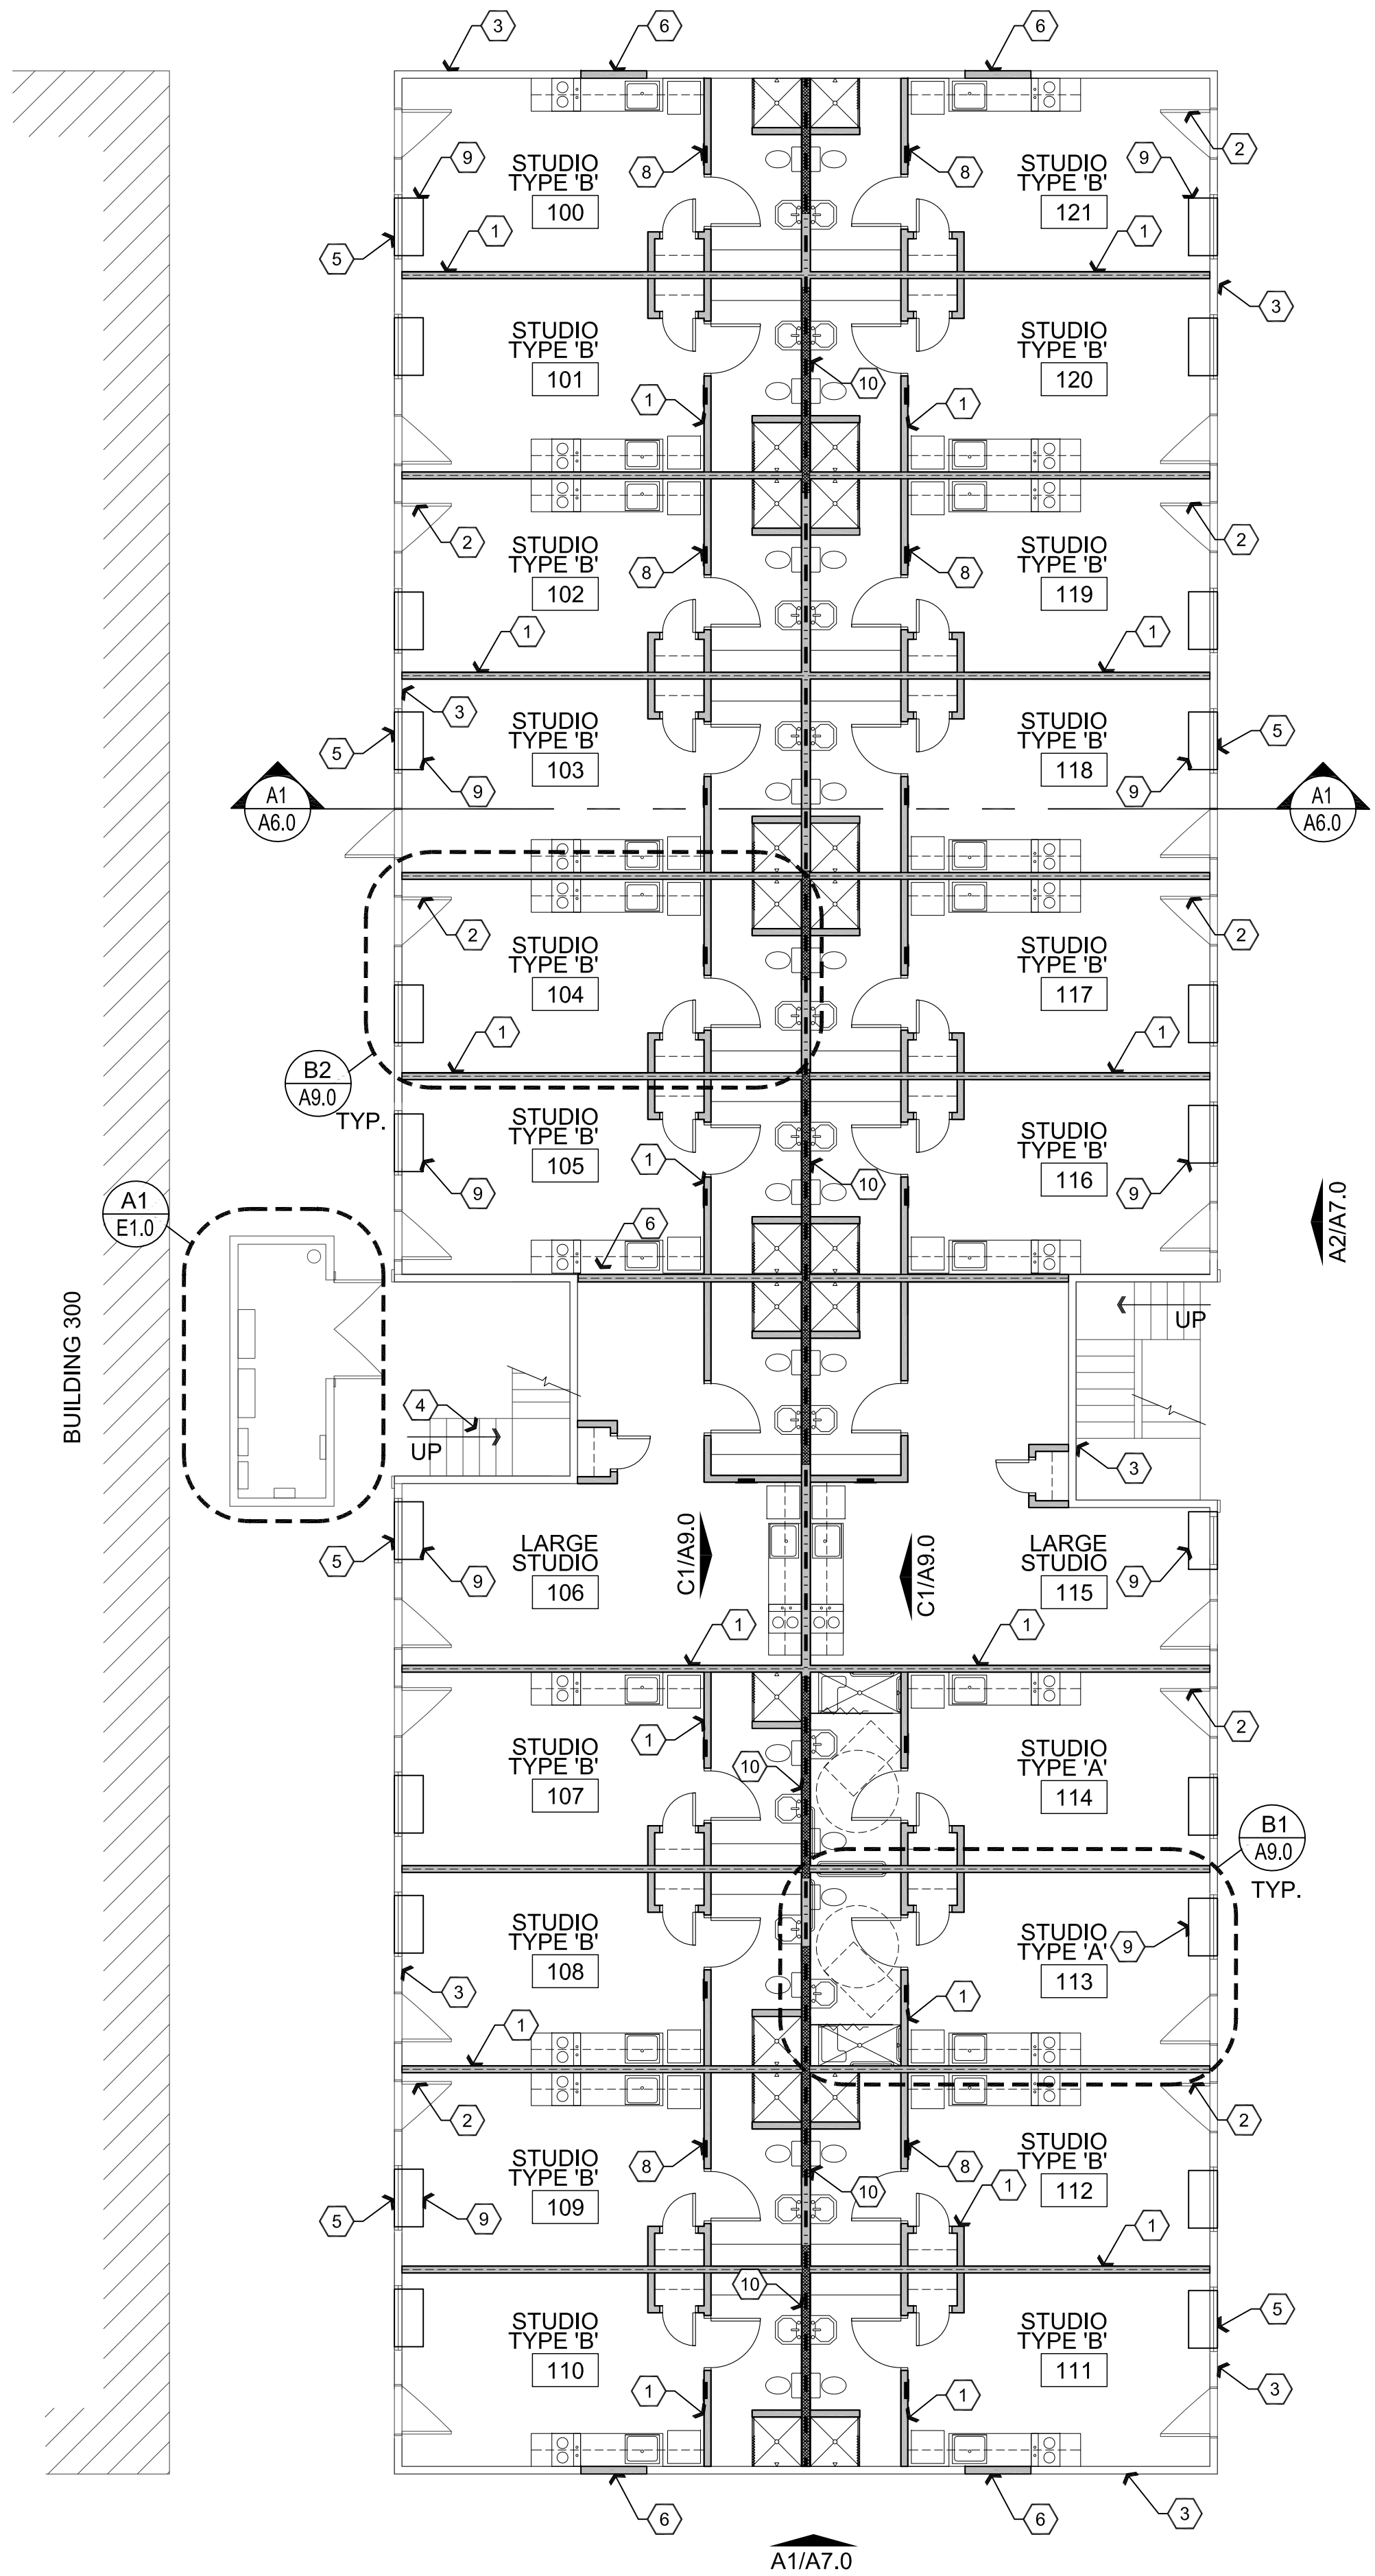


A1 Reference 1st Floor Plan B200

Scale: 1/8"=1'-0"



BUILDING 300

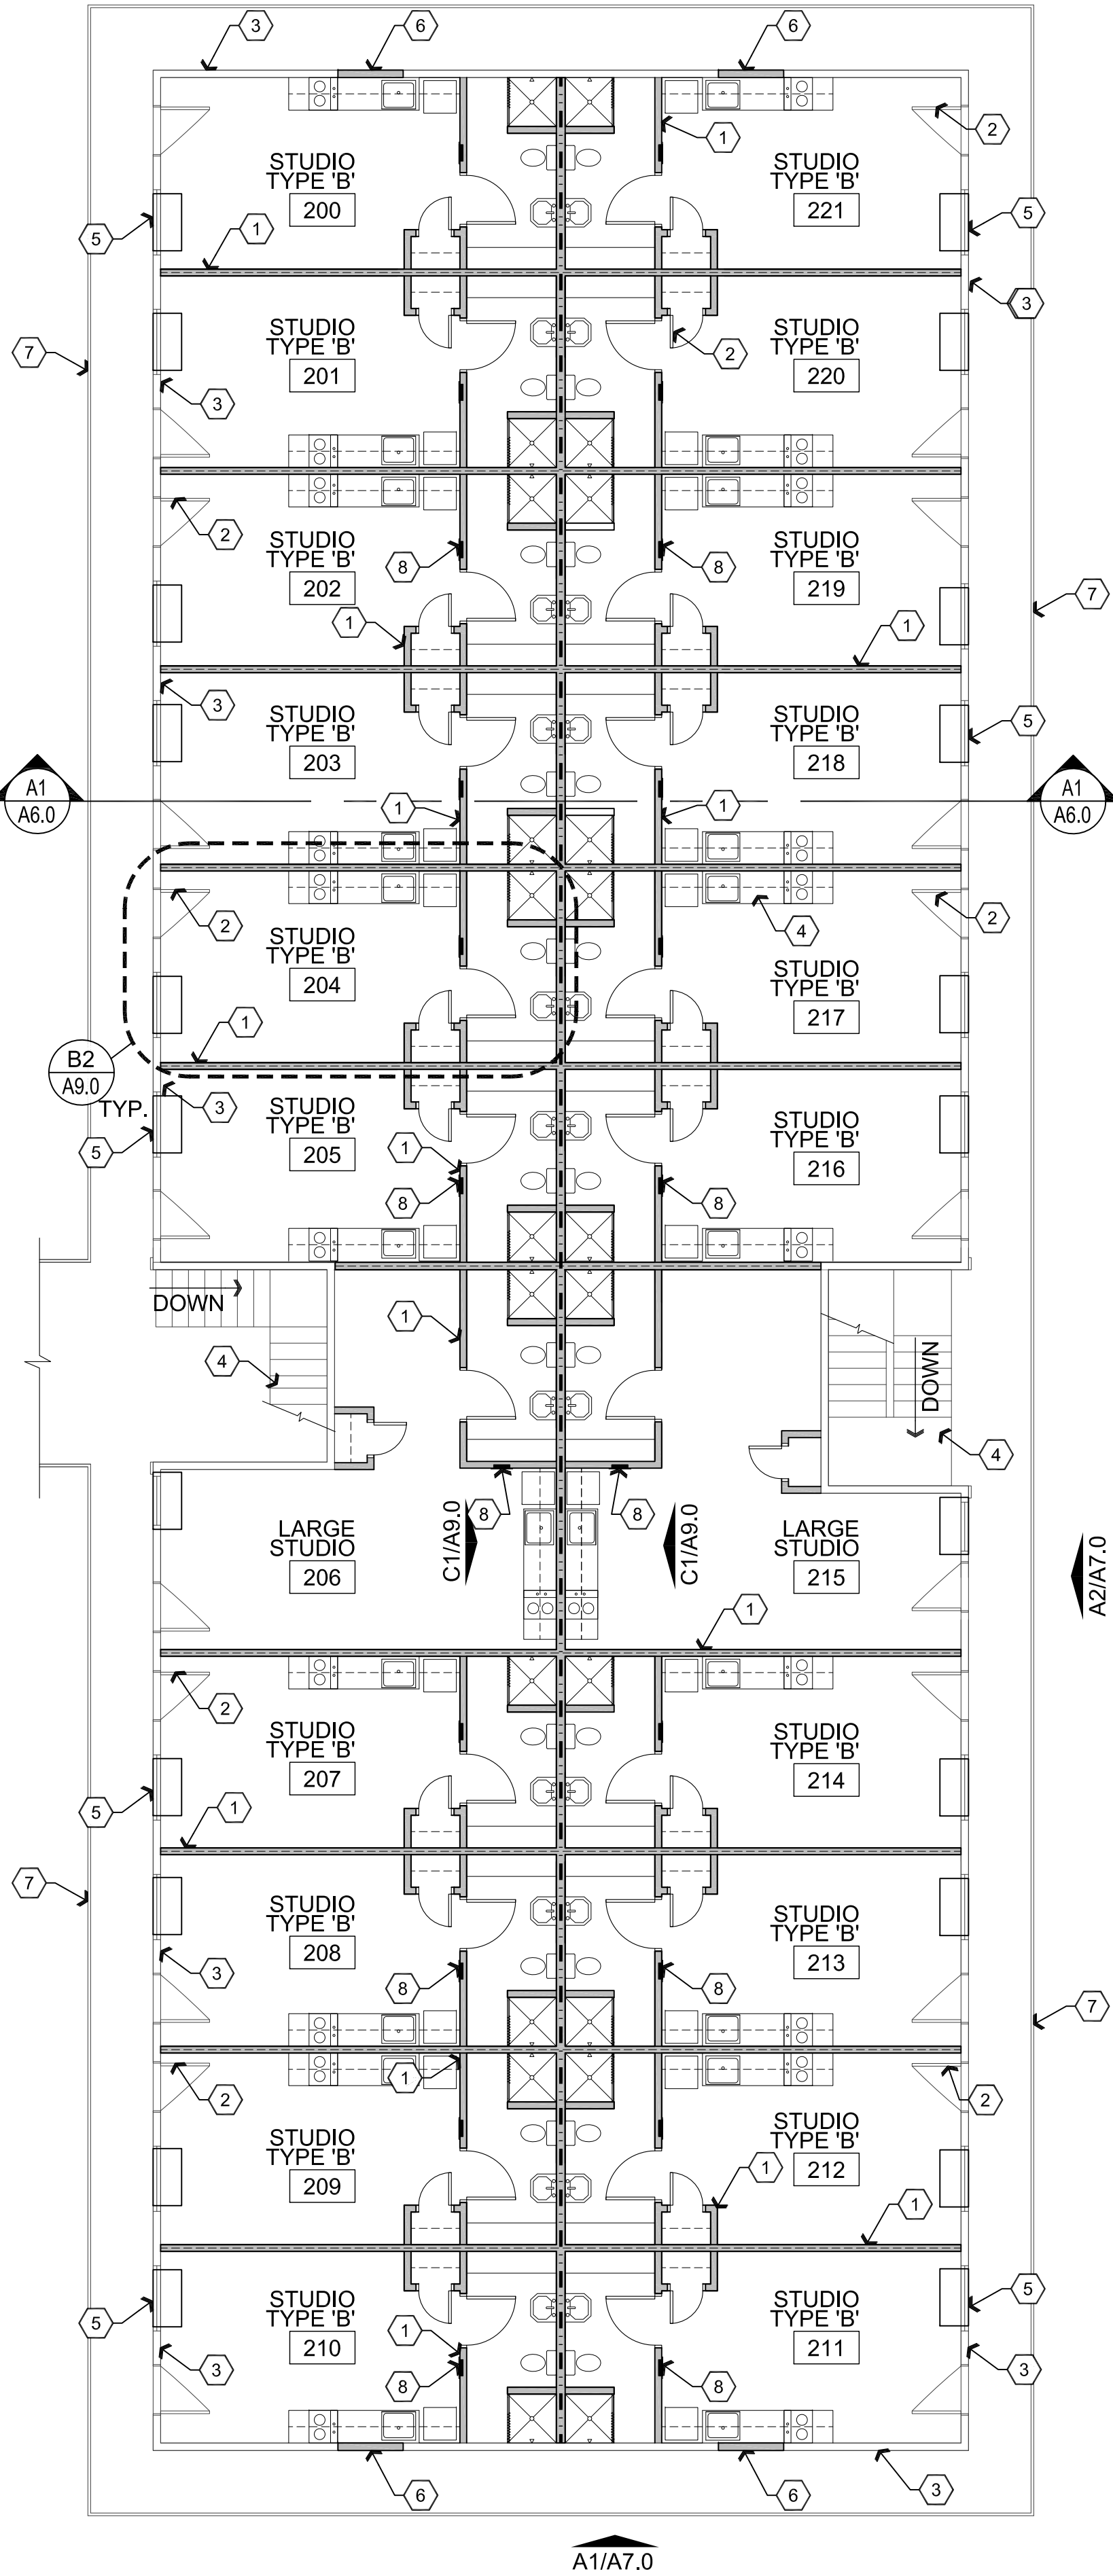

B1 Reference 2nd Floor Plan B200

Scale: 1/8"=1'-0"



Descriptive Keynotes

1. PROVIDE WALL, TYPICAL, REFER TO WALL TYPES.
2. EXISTING DOOR AND FRAME TO REMAIN, TYPICAL.
3. EXISTING EXTERIOR WALL TO REMAIN, TYPICAL.
4. EXISTING STAIRS TO REMAIN.
5. EXISTING WINDOW TO REMAIN.
6. INFILL WALL, WHERE WINDOW WAS REMOVED, TO MATCH EXISTING.
7. EXISTING EDGE OF BALCONY.
8. PROVIDE RECESSED ELECTRICAL PANEL, REFER TO ELECTRICAL PLANS.
9. PROVIDE PTAC HVAC UNIT, REFER TO MECHANICAL PLANS.
10. EXISTING PORTION OF BEARING WALL.

Wall Types Legend

- EXISTING EXTERIOR WALL
RETEXTURE EXISTING DRYWALL AS REQUIRED
- (NEW) INTERIOR 2x6 - 1 HOUR STUD WALL:
PROVIDE 1-LAYER 5/8" TYPE 'X' GPDW
ON EACH SIDE OF EXISTING OR NEW
2x6 WOOD STUDS AT 1'-4" O.C WITH
R-19 BATT INSULATION.
- (EXST) INTERIOR 2x4 - 1 HOUR STUD WALL:
PROVIDE 1-LAYER 5/8" TYPE 'X' GPDW
ON EACH EXPOSED SIDE OF 2x4 WOOD
STUDS AT 1'-4" ON CENTER WITH R-11
BATT INSULATION.
- INTERIOR 2x4 STUD WALL: PROVIDE
1-LAYER 1/2" GPDW ON EACH SIDE OF
2x4 WOOD STUDS AT 1'-4" O.C.

W. Alan Kenson & Associates, P.C.



P 928-443-5812
F 928-443-5815
email: waka@cableone.net
www.kenson-associates.com

DRAWING: Preliminary Architectural Reference Floor Plans

PROJECT: Renovation Project for Beck Legacy Group
1040 Whipple Street Building 200
Prescott, AZ 86305

APN: 115-09-008D

DRAWN BY
L.O.
CHECKED BY
W.A.K.
DATE
April 5th, 2018
JOB NO.
711
SHEET


A3.0

REVISIONS	BY

These drawings are the property of W. Alan Kenson & Associates P.C., and may not be reproduced in any way without the written consent of W. Alan Kenson & Associates, P.C.


PRELIMINARY NOT FOR CONSTRUCTION

Apr 05, 2018 - 2:47pm

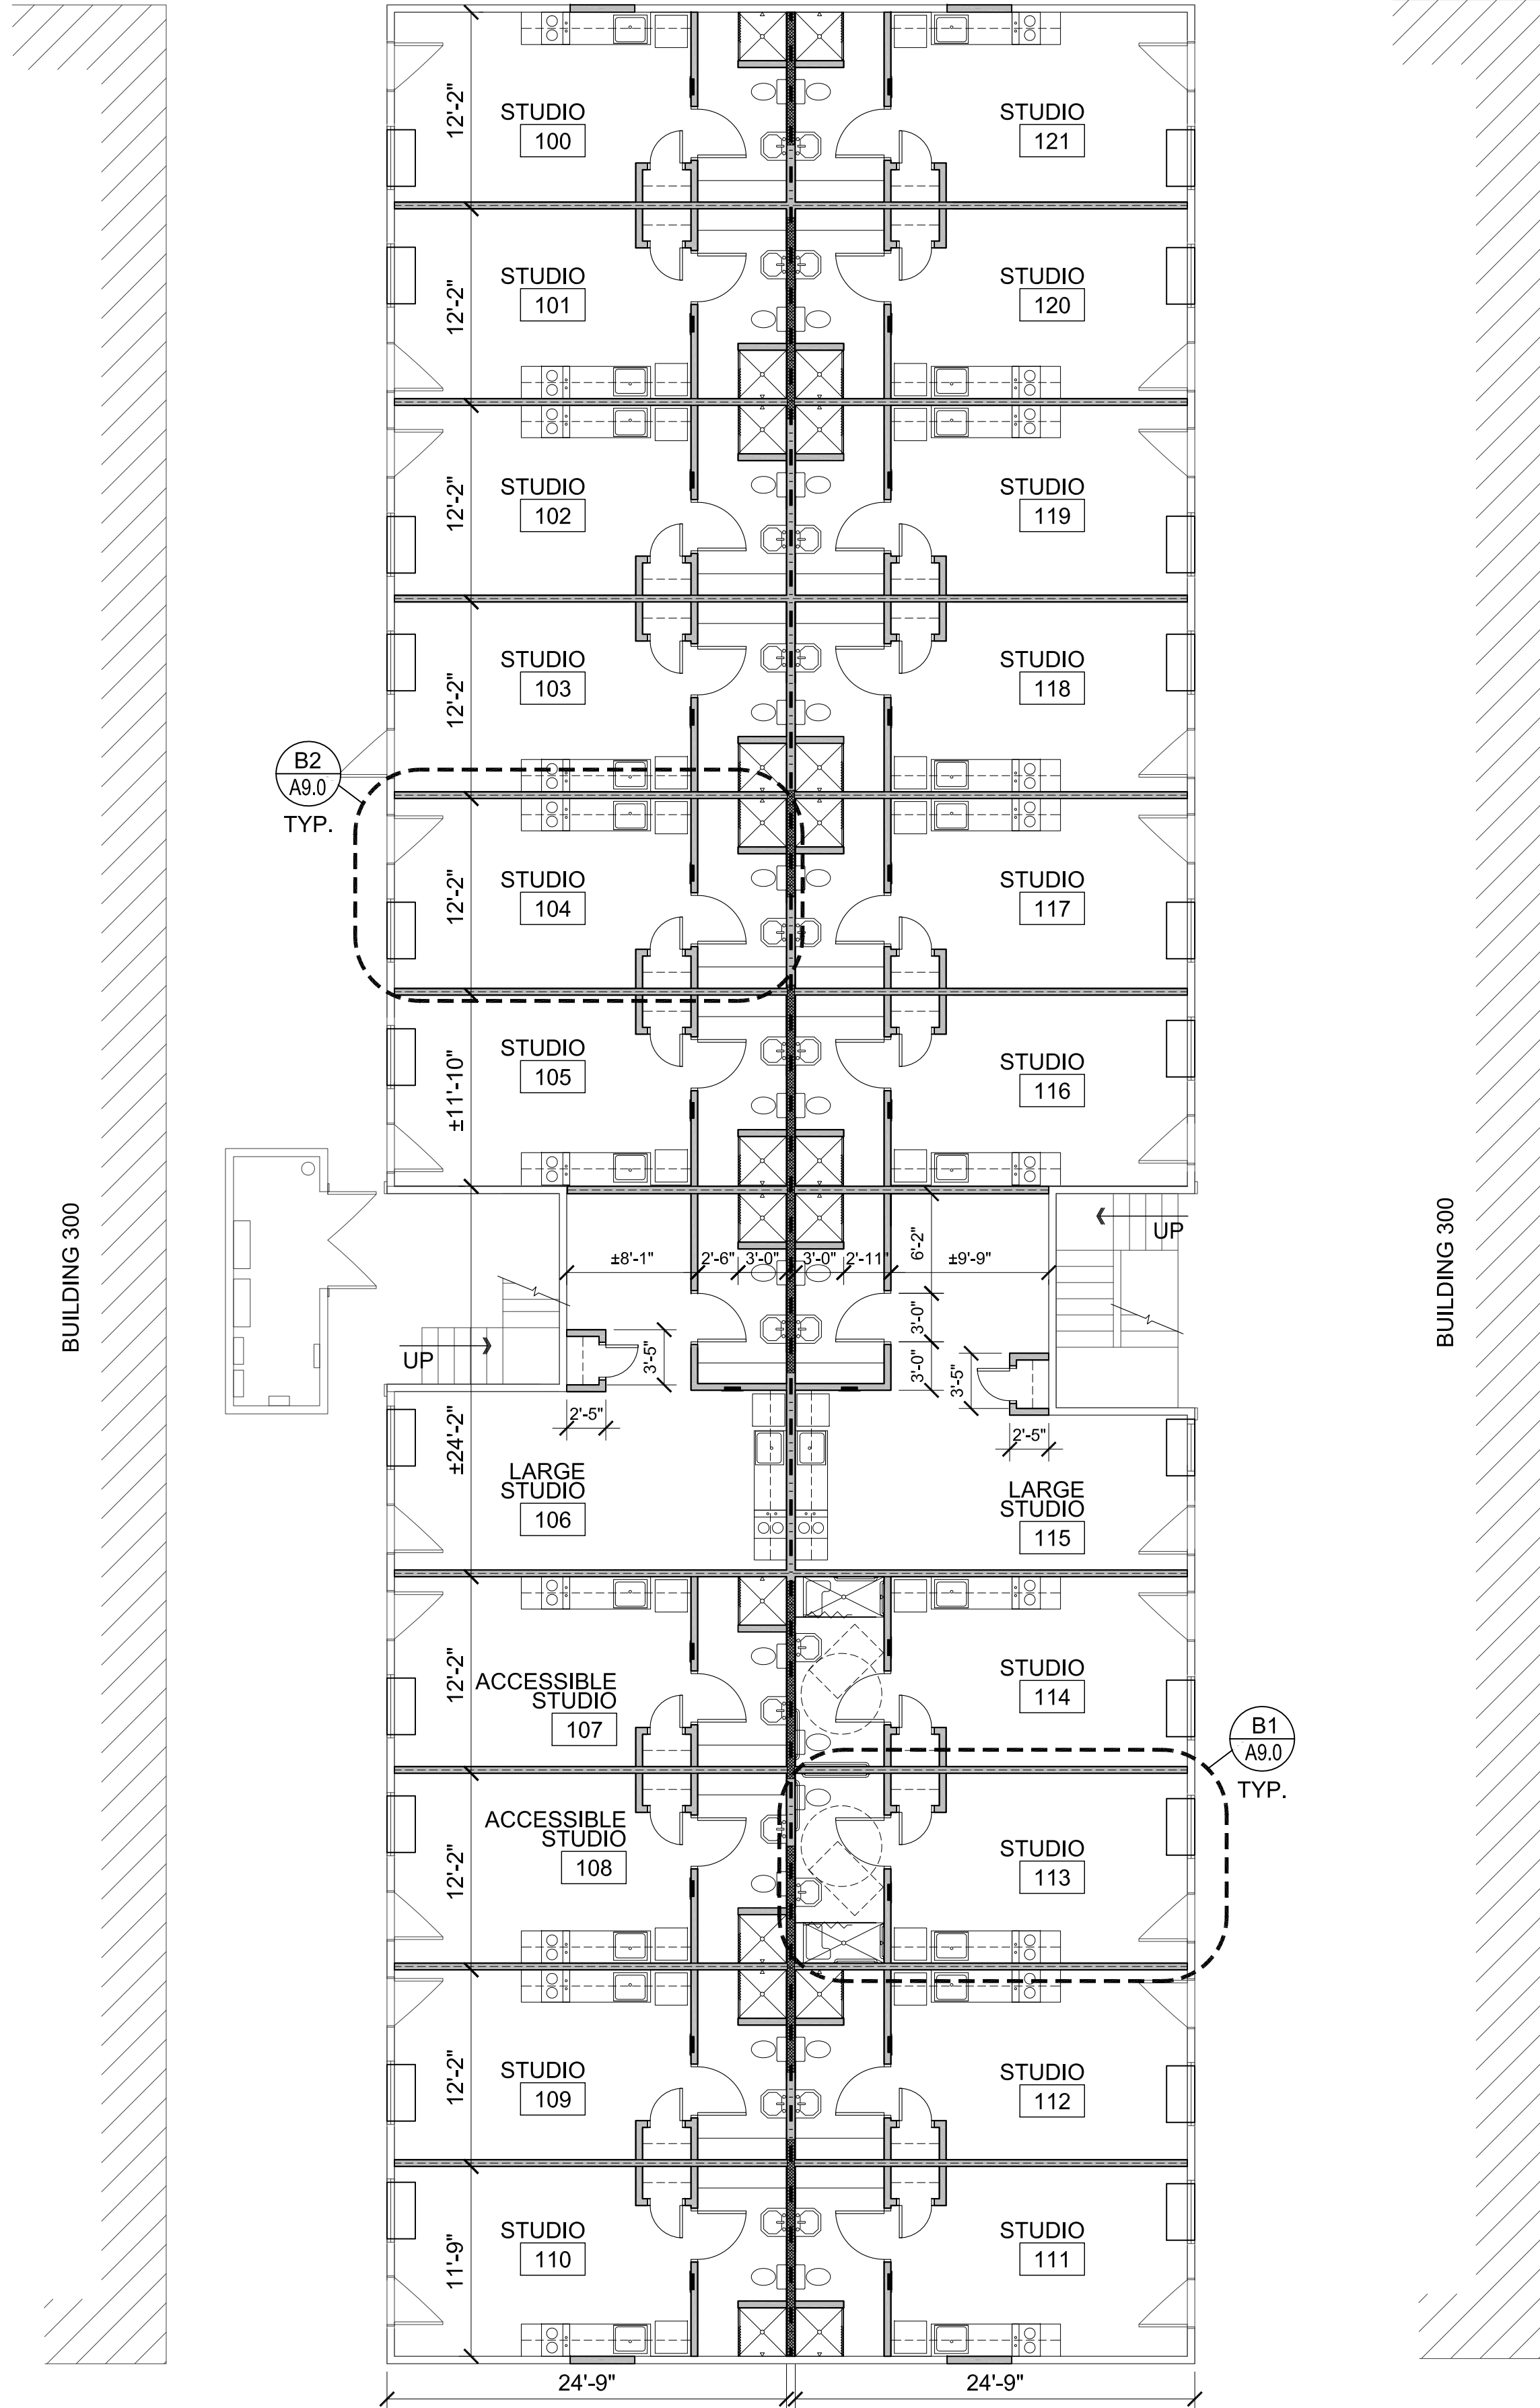

Dimension 1st Floor Plan B200

Scale: 1/8"=1'-0"

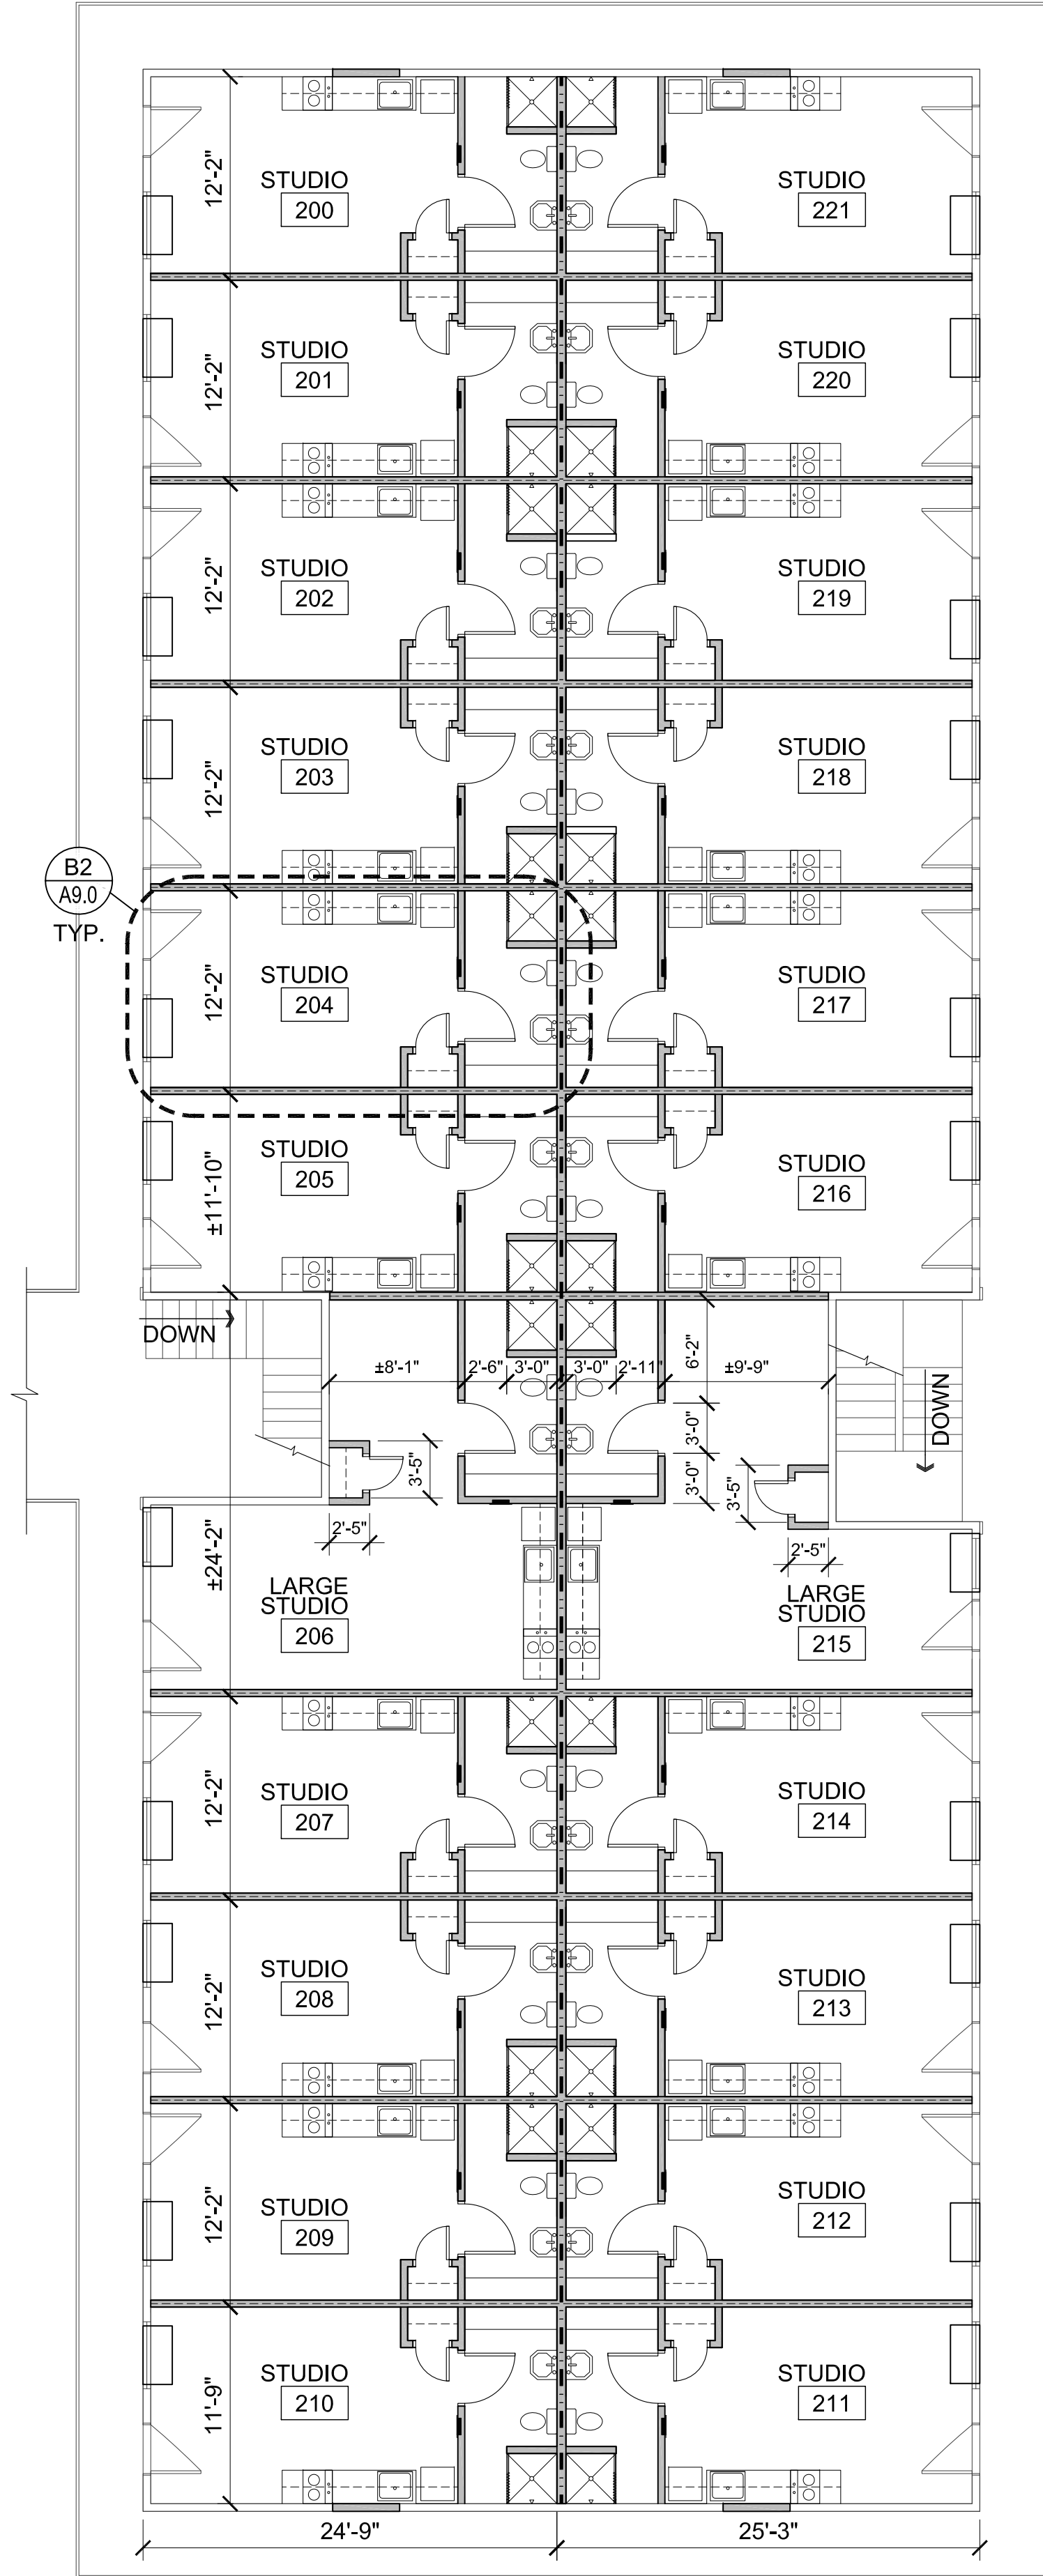

Dimension 2nd Floor Plan B200

Scale: 1/8"=1'-0"



REVISIONS	BY

These drawings are the property of W. Alan Kenson & Associates P.C., and may not be reproduced in any way without the written consent of W. Alan Kenson & Associates, P.C.

PRELIMINARY NOT FOR CONSTRUCTION



W. Alan Kenson & Associates, P.C.

P 928-443-5812
F 928-443-5815
email: waka@cableone.net
www.kenson-associates.com

ARCHITECTURE & PLANNING

P.O. Box 11593
Prescott, AZ 86304

DRAWING: Preliminary Architectural Dimension Floor Plans


PROJECT: Renovation Project for Beck Legacy Group
1040 Whipple Street Building 200
Prescott, AZ 86305

APN: 115-09-008D

DRAWN BY L.O.
CHECKED BY W.A.K.
DATE April 5th, 2018
JOB NO. 711
SHEET

A4.0

Apr 05, 2018 - 2:48pm

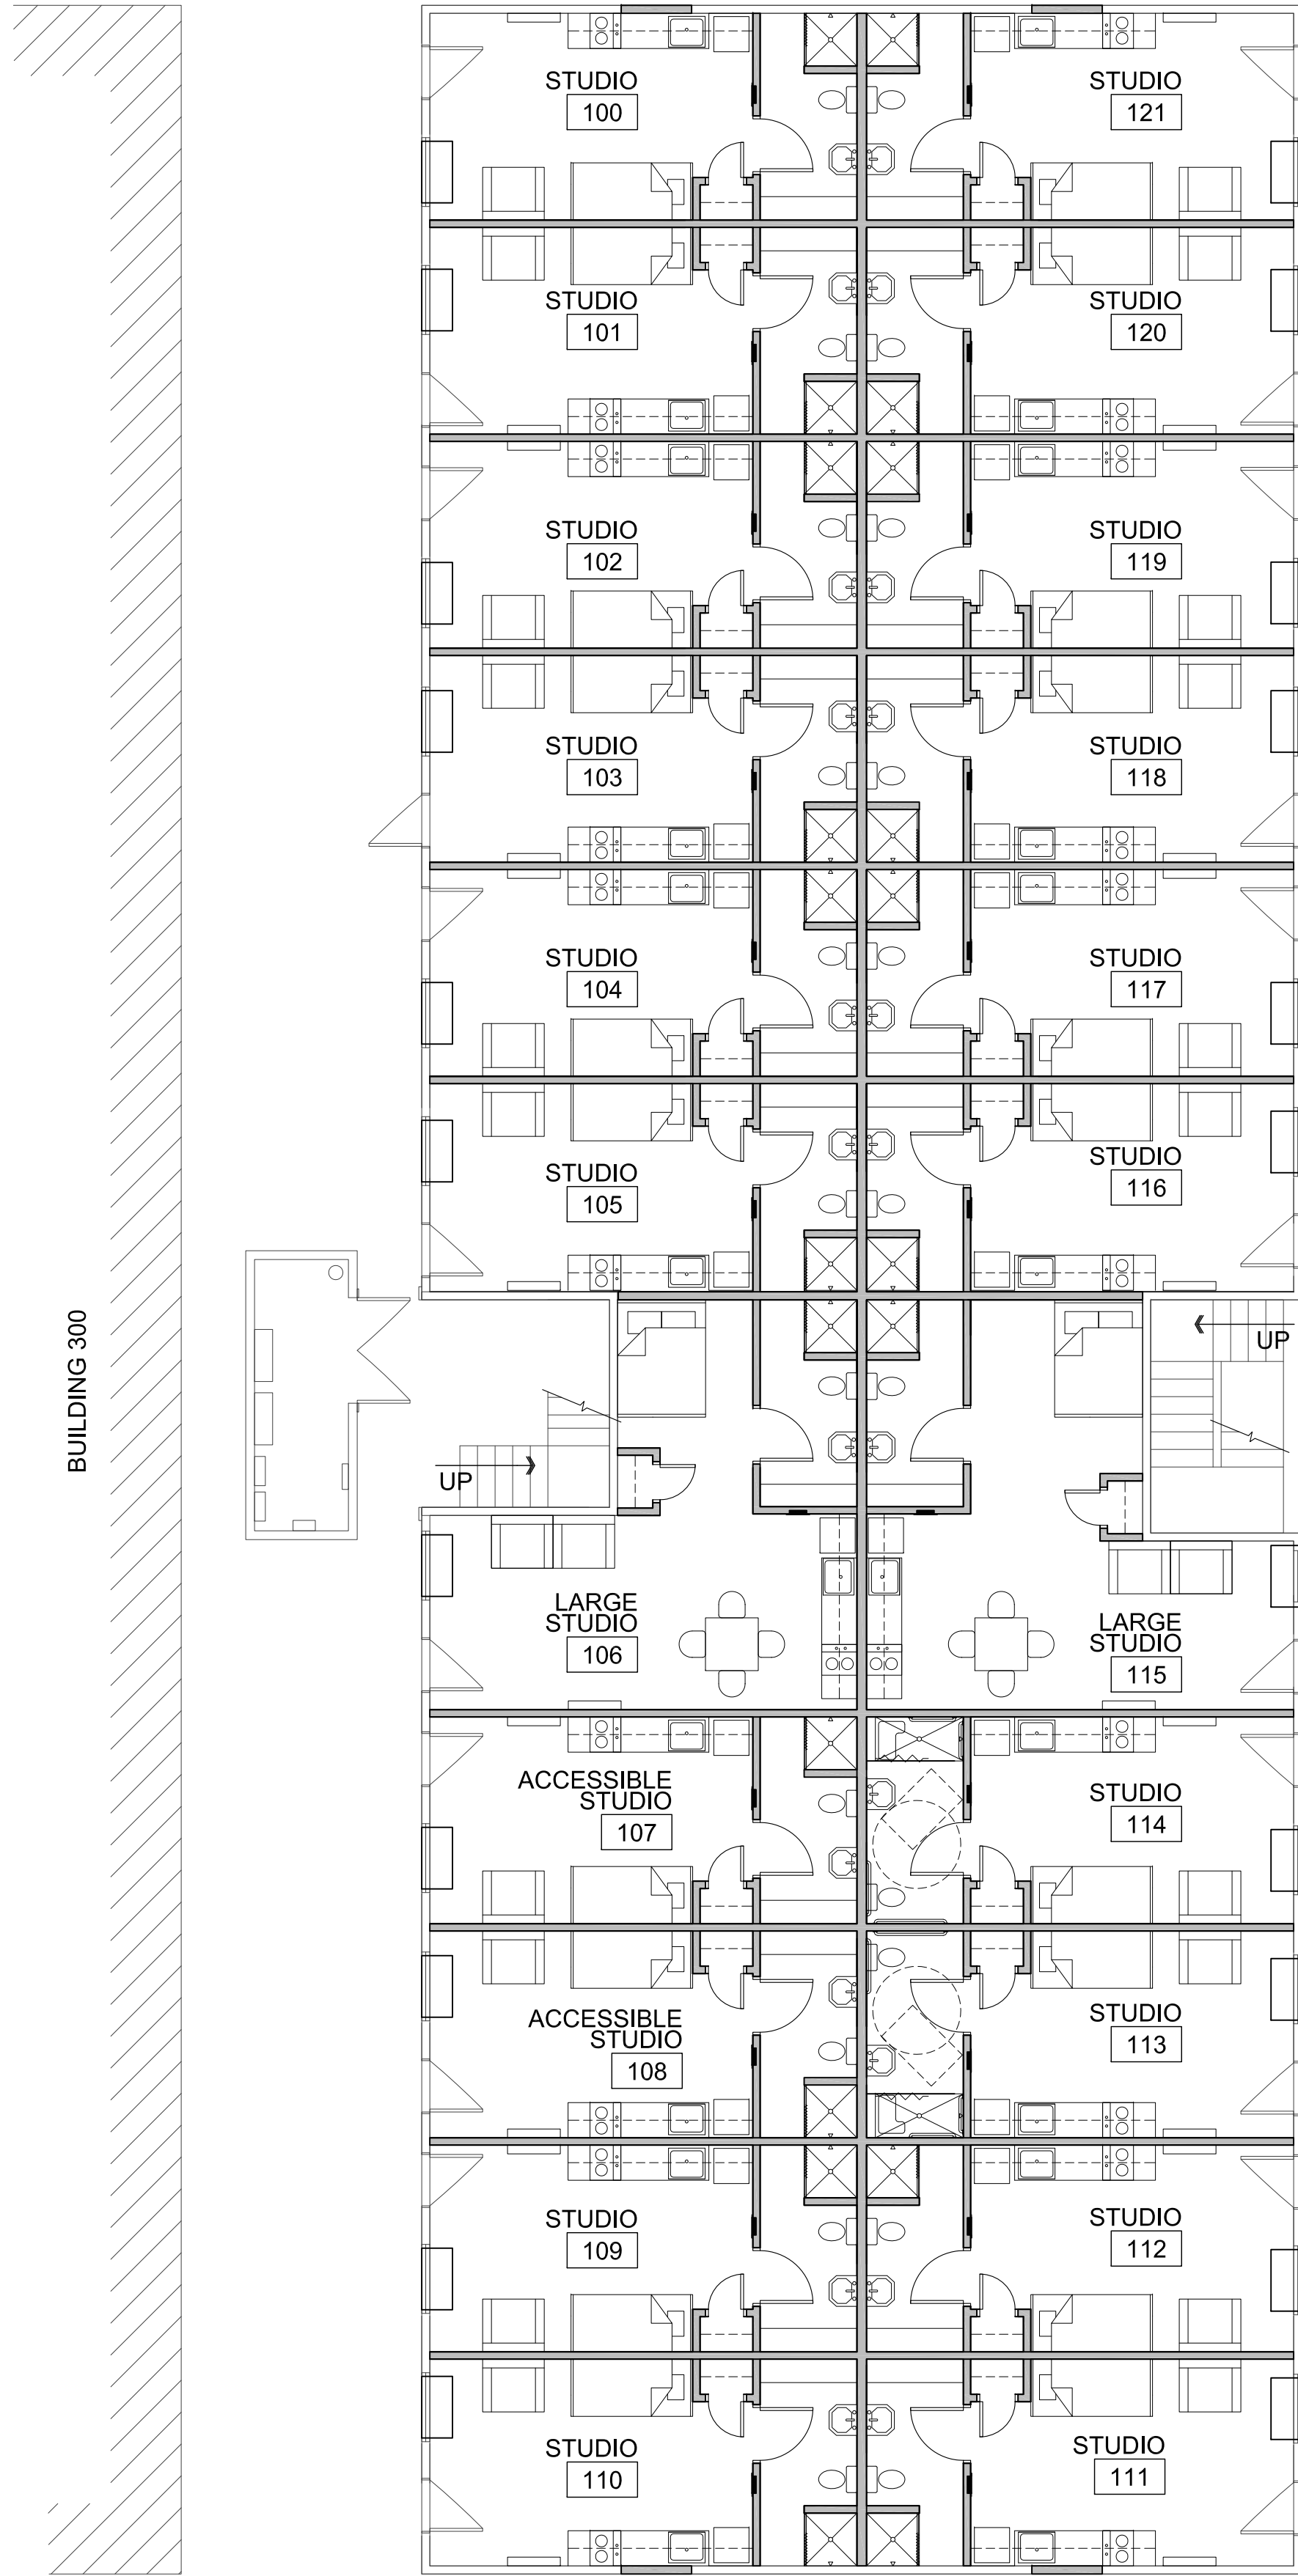


Furniture 1st Floor Plan B200

Scale: 1/8"=1'-0"



BUILDING 300

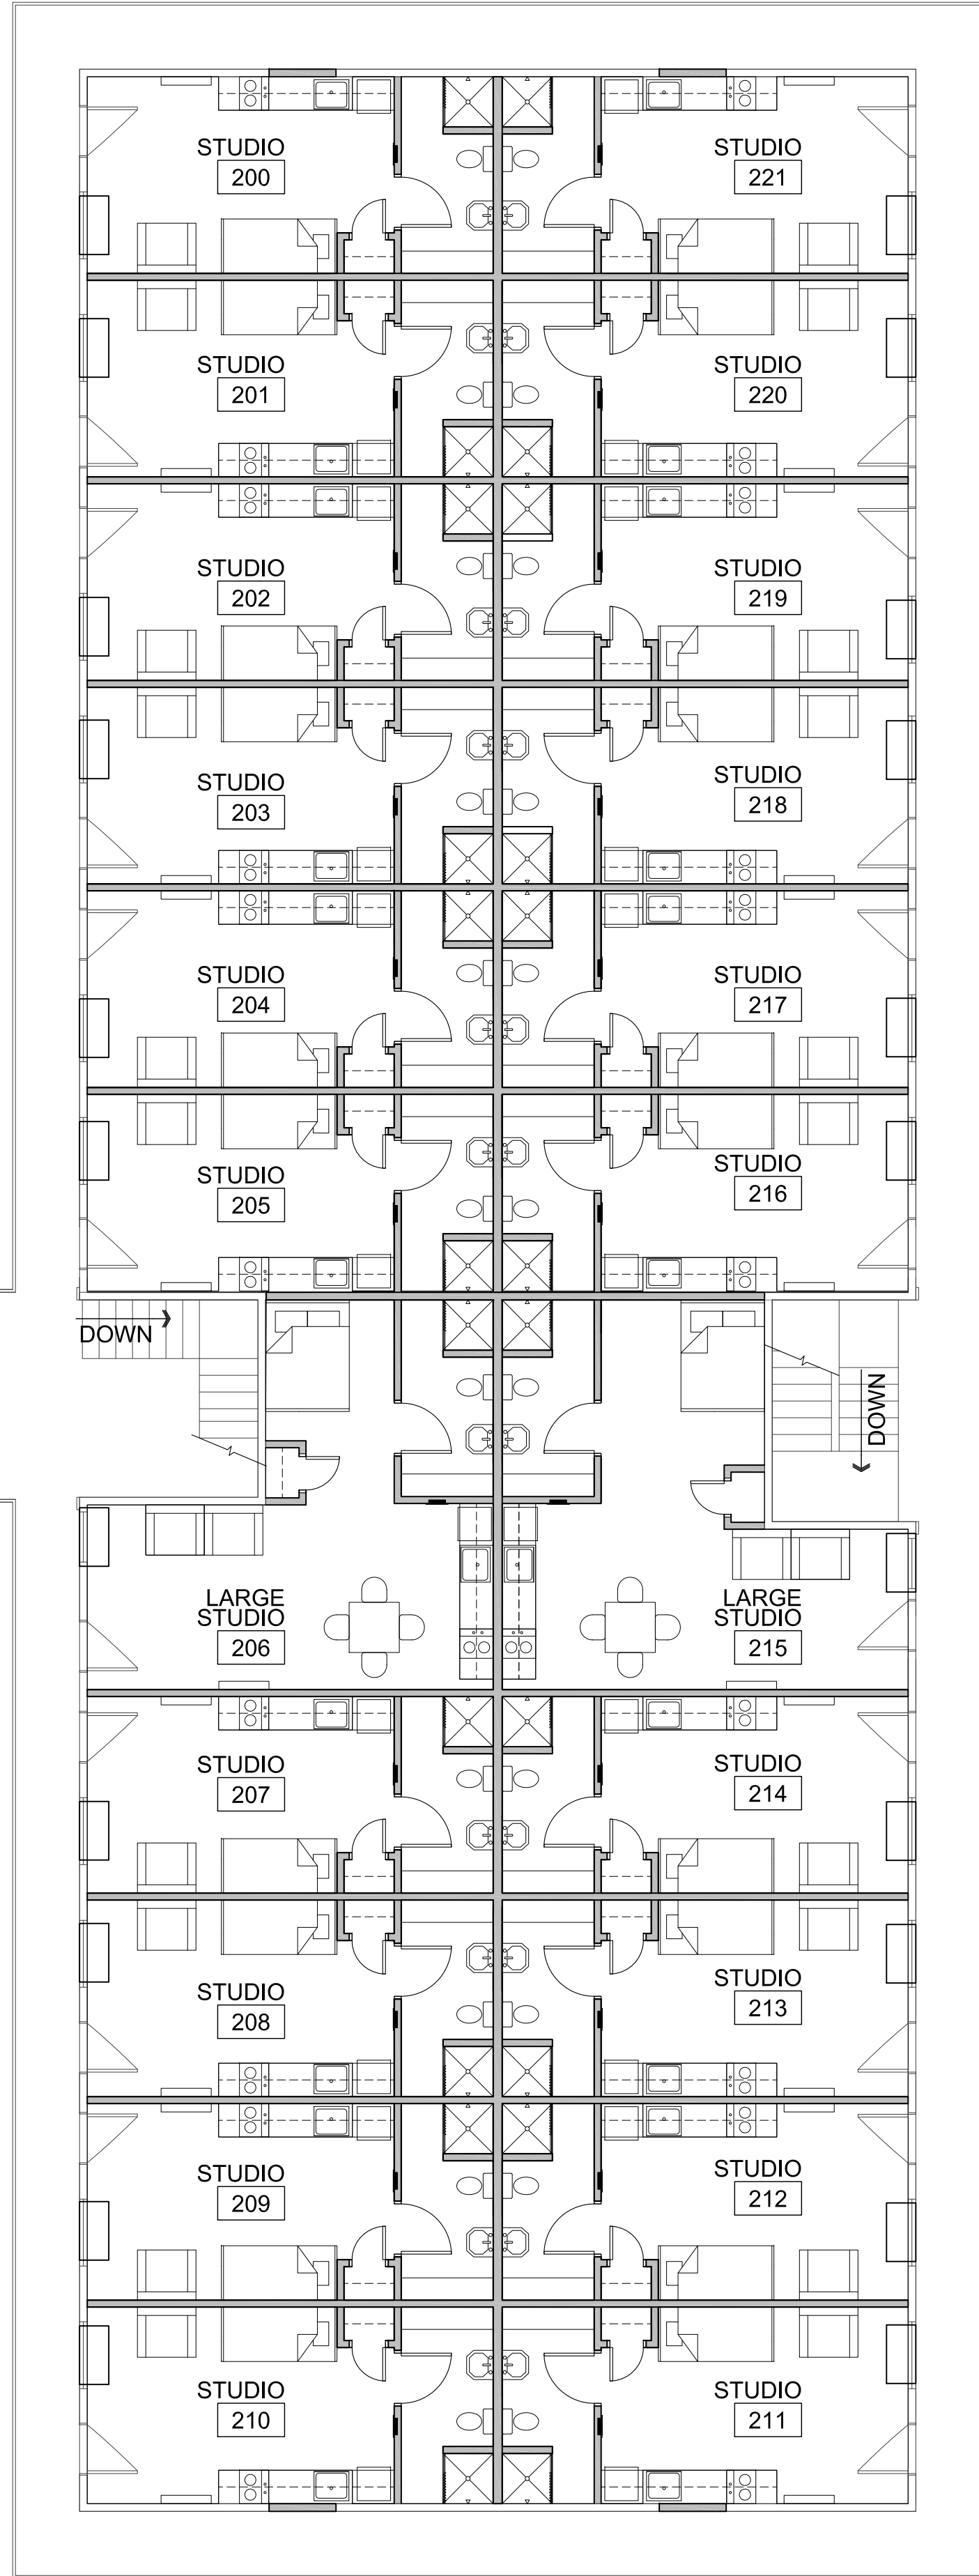

Furniture 2nd Floor Plan B200

Scale: 1/8"=1'-0"



REVISIONS	BY

These drawings are the property of W. Alan Kenson & Associates P.C., and may not be reproduced in any way without the written consent of W. Alan Kenson & Associates, P.C.

PRELIMINARY NOT FOR CONSTRUCTION

W. Alan Kenson & Associates, P.C.



P 928-443-5812 P.O. Box 11593
F 928-443-5815 Prescott, AZ 86304
email: waka@cableone.net
www.kenson-associates.com

ARCHITECTURE & PLANNING


DRAWING: Preliminary Furniture Plans

PROJECT: Renovation Project for Beck Legacy Group
1040 Whipple Street Building 200
Prescott, AZ 86305

APN: 115-09-008D

DRAWN BY L.O.
CHECKED BY W.A.K.
DATE April 5th, 2018
JOB NO. 711
SHEET

A5.0

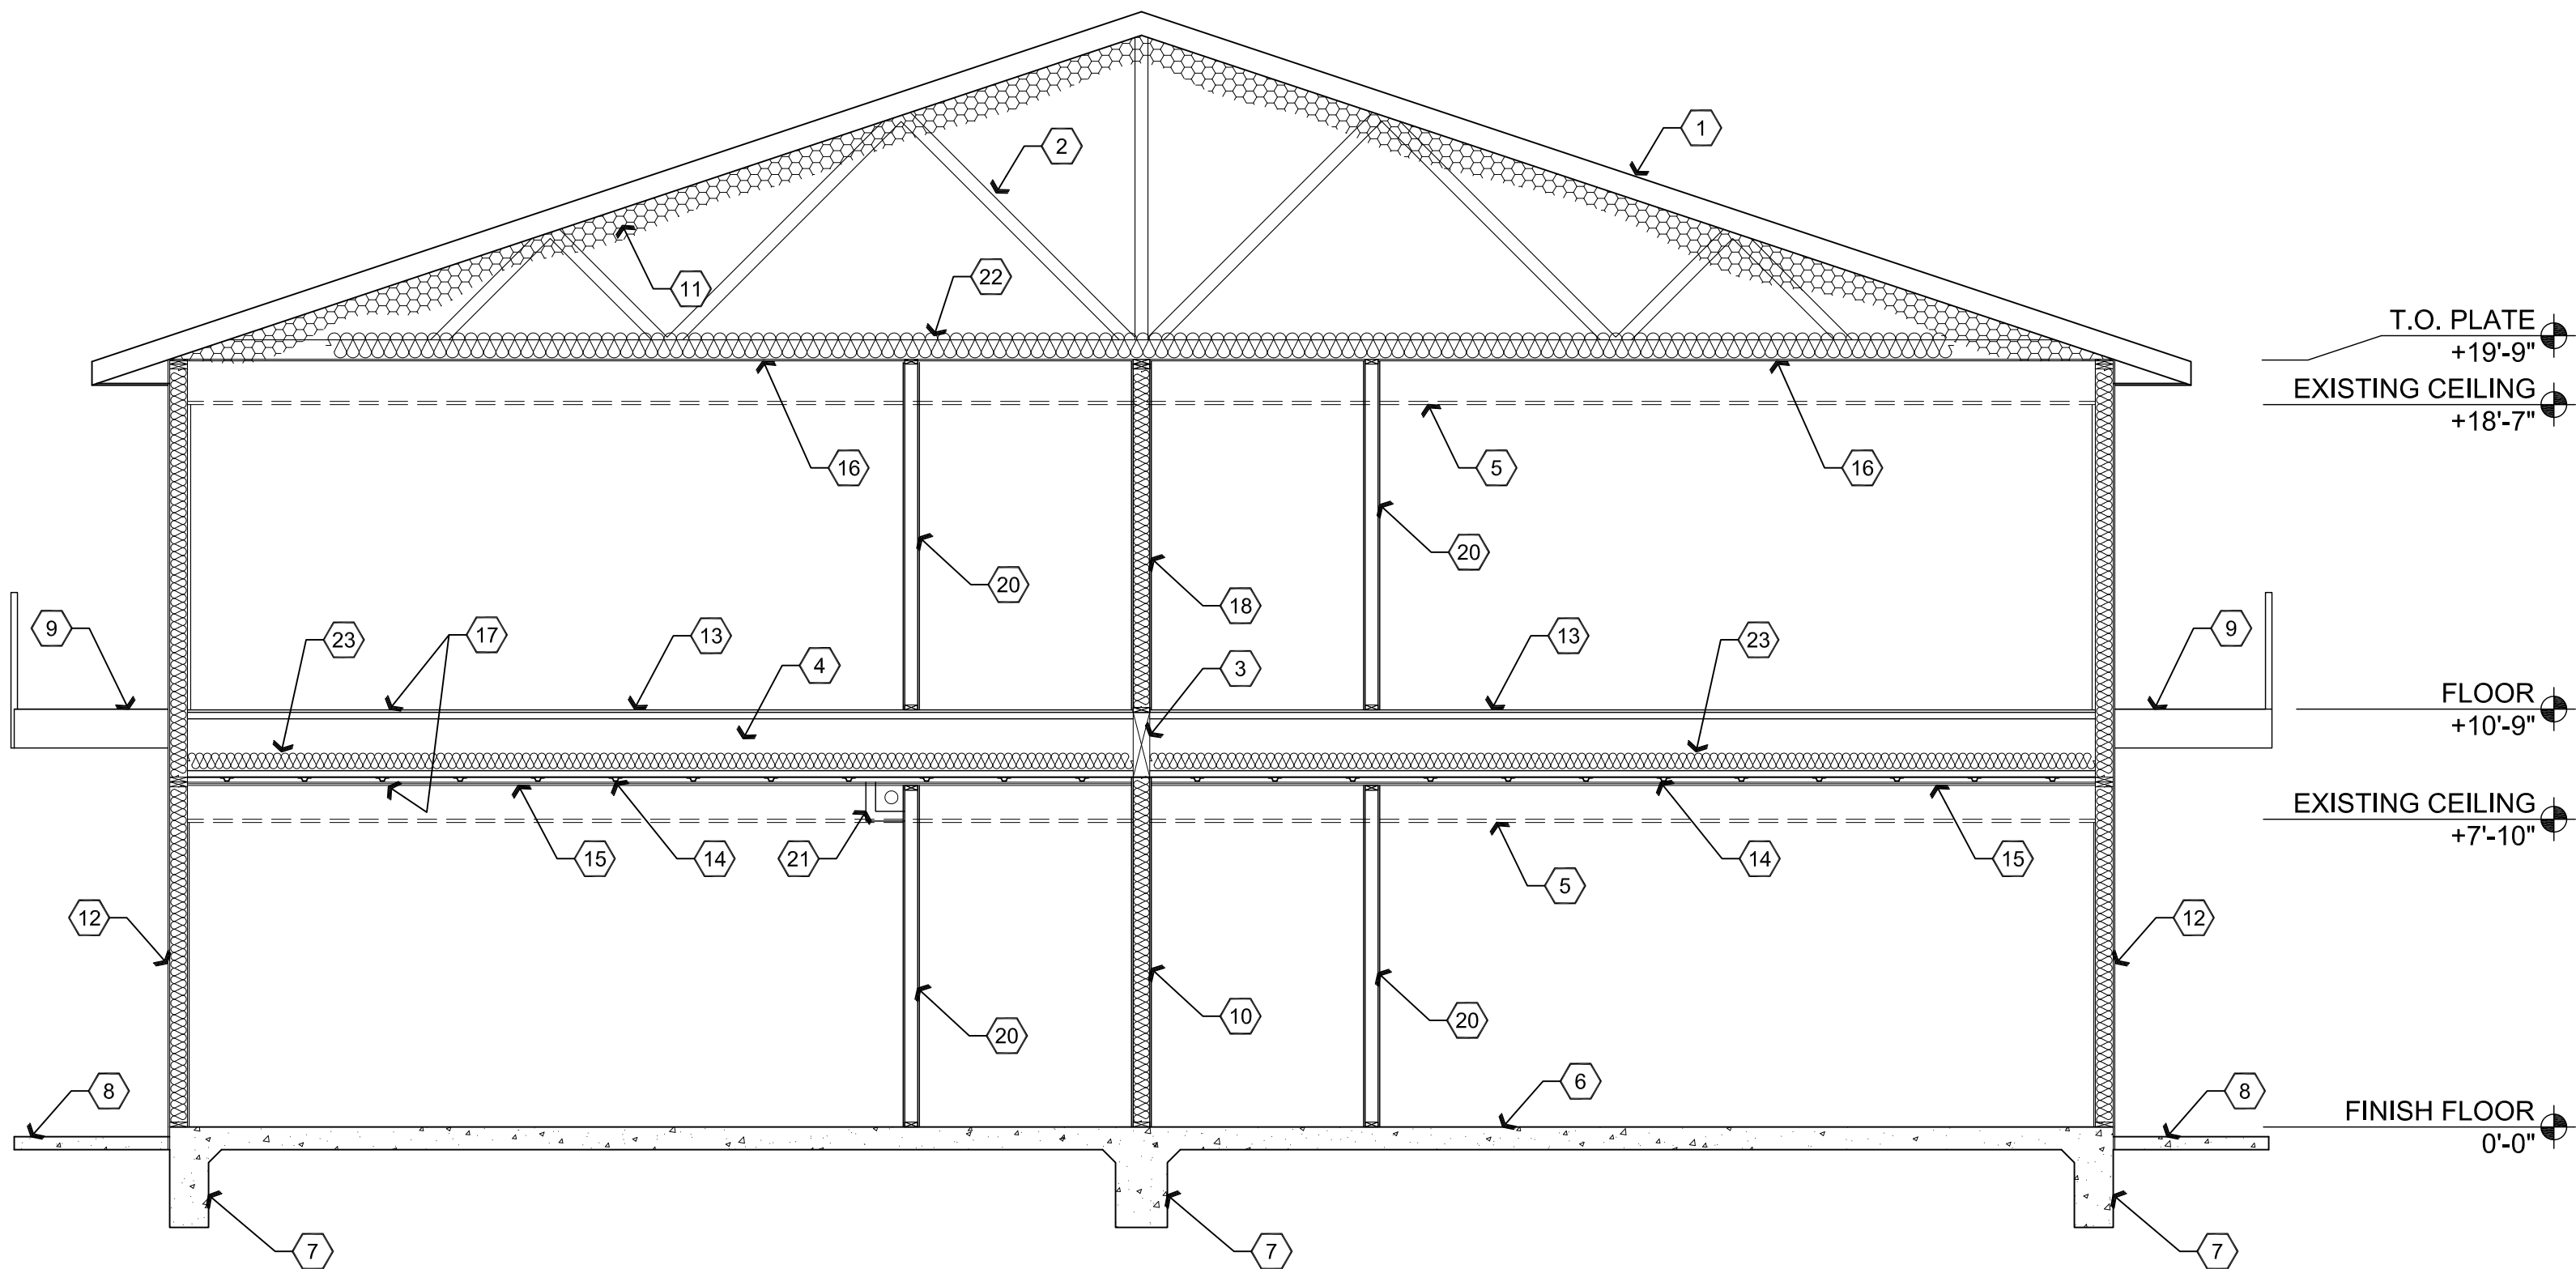

Descriptive Keynotes

- 1. EXISTING ROOF.
- 2. EXISTING TRUSS.
- 3. EXISTING 5 1/8x20 GLU-LAM BEAM (OCCURS WHERE BEARING WALLS ARE ABSENT).
- 4. EXISTING 20" TJI JOIST @ 16" O.C.
- 5. EXISTING ACOUSTICAL GRID CEILING TO BE REMOVED.
- 6. EXISTING CONCRETE SLAB.
- 7. EXISTING CONCRETE FOOTING.
- 8. EXISTING CONCRETE SIDEWALK.
- 9. EXISTING EXTERIOR DECKING.
- 10. EXISTING / NEW 2x6 STUD BEARING WALL, REFER TO WALL TYPES.
- 11. PROPOSED R-38 OPEN CELL INSULATION.
- 12. EXISTING EXTERIOR 2x6 WALL W/ EXISTING DRYWALL TO REMAIN ON INTERIOR AS WELL AS R-19 BATT INSULATION AND STUCCO ON EXTERIOR.
- 13. EXISTING 3/4" FLOOR SHEATHING.
- 14. PROVIDE RESILIENT CHANNELS @ 1'-4' O.C.
- 15. PROVIDE 2 LAYERS 1/2" TYPE 'X' GPDW.
- 16. REMOVE EXISTING GPDW CEILING AND REPLACE WITH 1/2" GPDW CEILING.
- 17. 1 HOUR FIRE RESISTIVE FLOOR / CEILING ASSEMBLY, REFER TO AMERICAN WOOD COUNCIL DETAIL WIJ-1.7
- 18. NEW 2x6, NON BEARING WALL, REFER TO WALL TYPES.
- 19. REMOVE EXISTING BLOWN-IN INSULATION.
- 20. NEW 2x4 WALL, REFER TO WALL TYPES.
- 21. PROVIDE 1'-0"x1'-0" SOFFIT CHASE FOR FIRE SPRINKLER LINE.
- 22. REMOVE EXISTING 'BLOWN IN' ATTIC INSULATION.
- 23. PROVIDE R-19 UNFACED BATT INSULATION.

Building Section B200

Scale: 1/4"=1'-0"

REVISIONS	BY

These drawings are the property of W. Alan Kenson & Associates P.C., and may not be reproduced in any way without the written consent of W. Alan Kenson & Associates, P.C.

PRELIMINARY NOT FOR CONSTRUCTION

W. Alan Kenson & Associates, P.C.

P 928-443-5812

F 928-443-5815

email: waka@cableone.net

www.kenson-associates.com

REGISTERED ARCHITECT

W.A.K.

STATE OF ARIZONA

P.O. Box 11593

Prescott, AZ 86304

ARCHITECTURE & PLANNING

115-09-008D

DRAWING: Preliminary Building Sections


PROJECT: Renovation Project for Beck Legacy Group
1040 Whipple Street Building 200
Prescott, AZ 86305

APN: 115-09-008D


DRAWN BY L.O.
CHECKED BY W.A.K.
DATE April 5th, 2018
JOB NO. 711
SHEET

A6.0

Apr 05, 2018 - 2:48pm

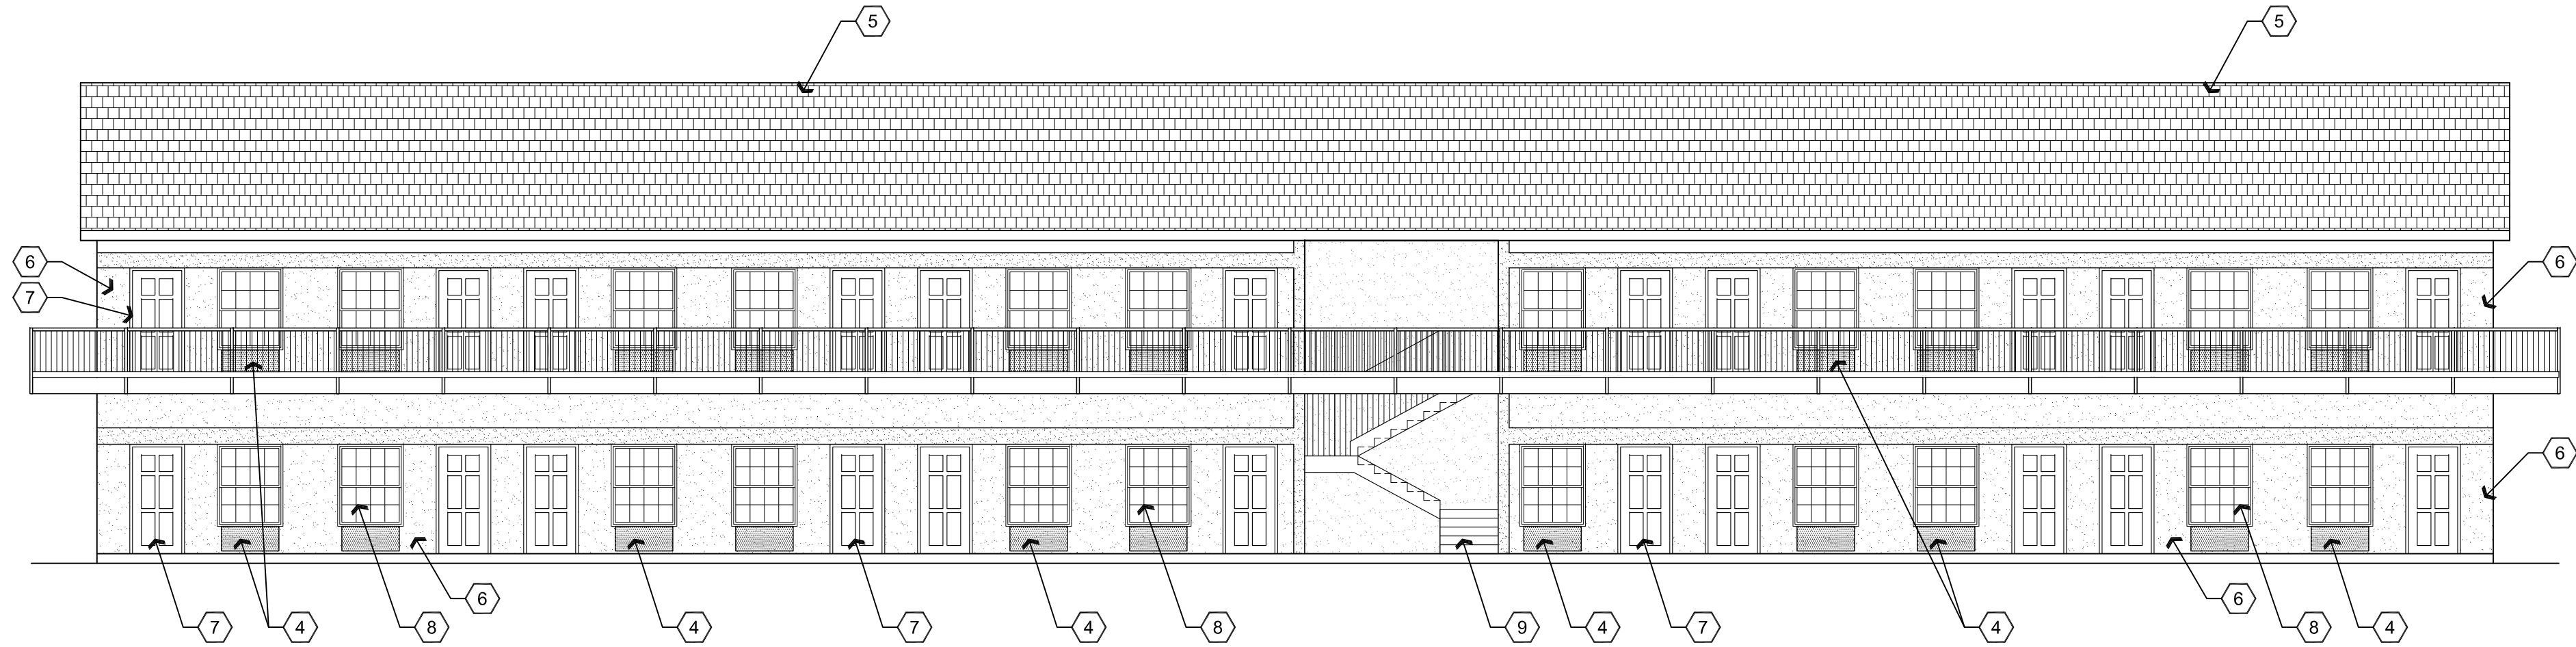

A2 Building 200 East Elevation
West Elevation Similar
Scale: 1/8"=1'-0"

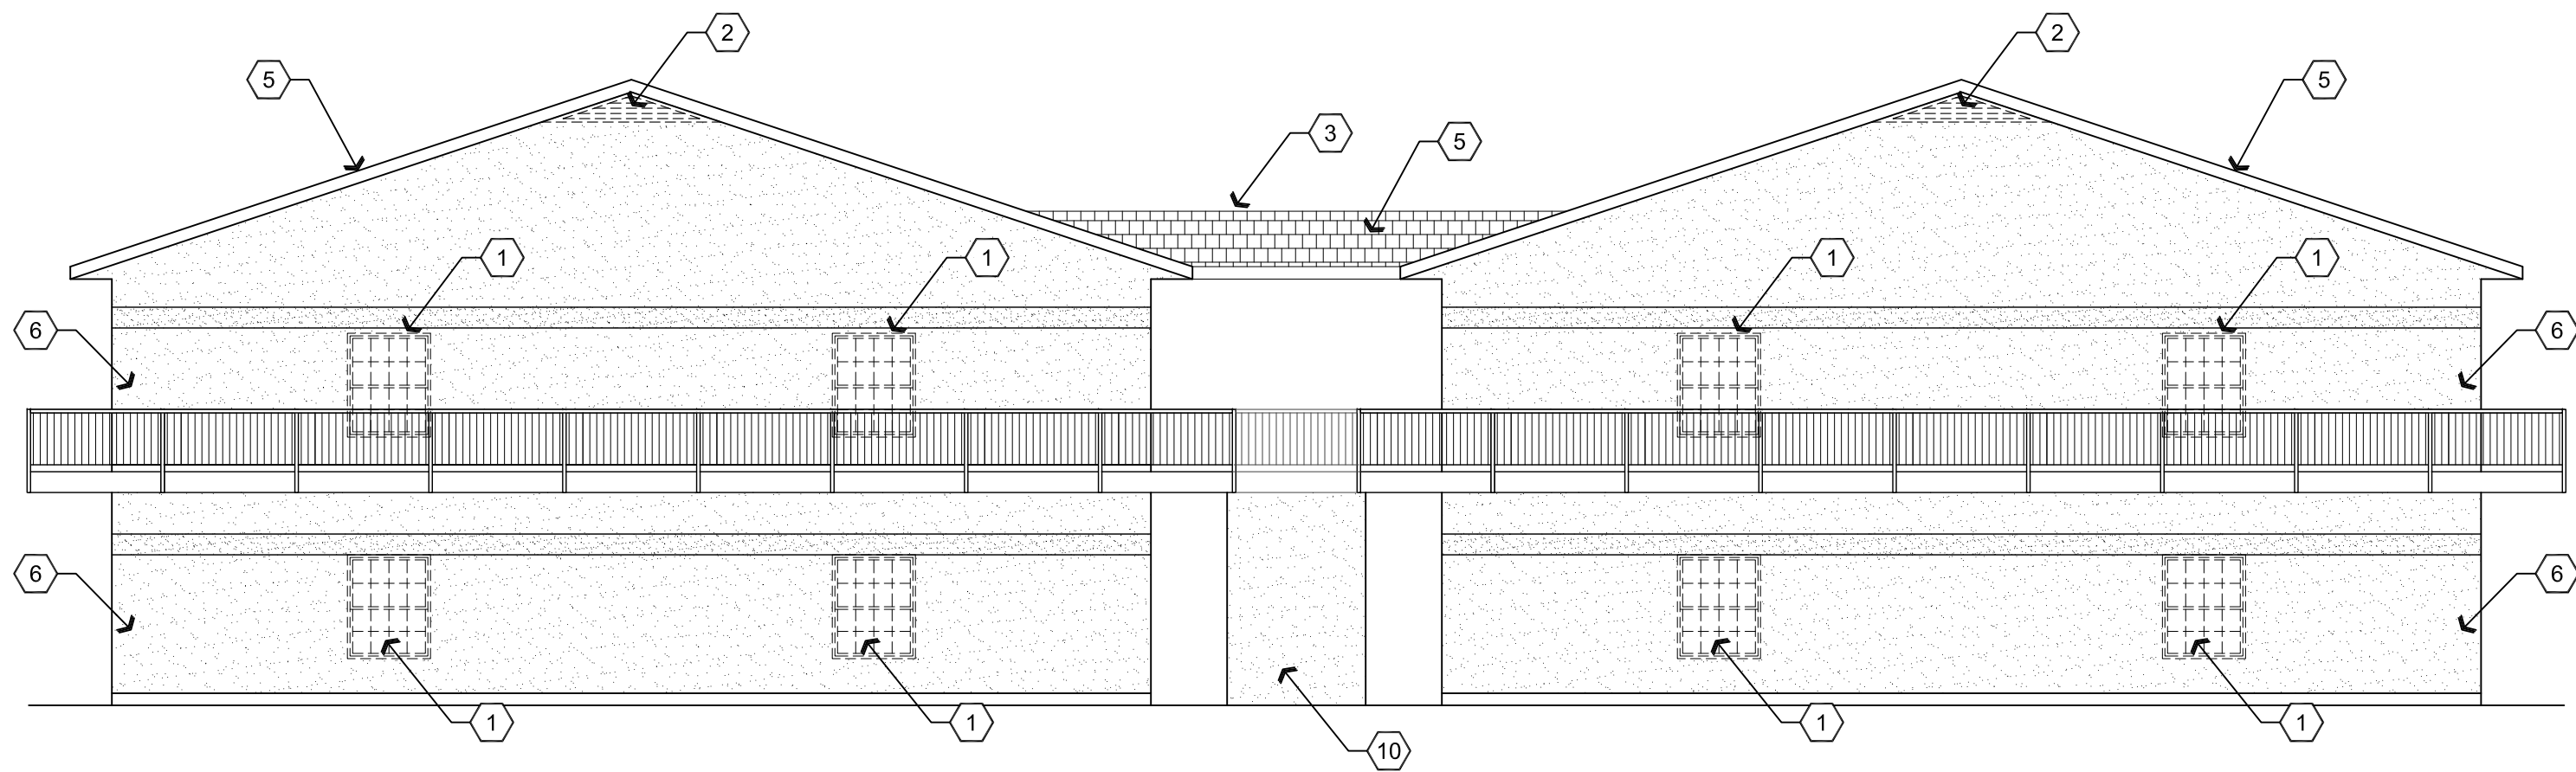

BUILDING 300

BUILDING 200

A1 Building 200 and 300 South Elevation
North Elevation Similar
Scale: 1/8"=1'-0"

Descriptive Keynotes

1. REMOVE EXISTING WINDOW NORTH AND SOUTH END, INFILL AS REQUIRED TO MATCH EXISTING.
2. REMOVE EXISTING ATTIC VENTS, INFILL AS REQUIRED TO MATCH EXISTING.
3. EXISTING COVERED WALKWAY.
4. PROVIDE PTAC HVAC UNIT BELOW WINDOW, TYPICAL, REFER TO MECHANICAL PLANS.
5. EXISTING ROOF, NO WORK REQUIRED.
6. EXISTING STUCCO EXTERIOR WALL. NO PAINTING REQUIRED.
7. EXISTING DOOR TO REMAIN, TYPICAL.
8. EXISTING WINDOW TO REMAIN, TYPICAL.
9. EXISTING STAIRS TO REMAIN.
10. EXISTING ELECTRICAL ROOM.

REVISIONS	BY

These drawings are the property of W. Alan Kenson & Associates P.C., and may not be reproduced in any way without the written consent of W. Alan Kenson & Associates, P.C.

PRELIMINARY NOT
FOR CONSTRUCTION

W. Alan Kenson & Associates, P.C.



P 928-443-5812 P.O. Box 11593
F 928-443-5815 Prescott, AZ 86304
email: waka@cableone.net
www.kenson-associates.com

ARCHITECTURE & PLANNING

DRAWING: Preliminary Exterior Elevations

PROJECT: Renovation Project for Beck Legacy Group
1040 Whipple Street Building 200
Prescott, AZ 86305

APN: 115-09-008D

DRAWN BY
L.O.

CHECKED BY
W.A.K.

DATE
April 5th, 2018



JOB NO.
711

SHEET

A7.0

Materials schedule XX- #				
CODE	MATERIAL	LOCATION	MANUFACTURER	SPECIFICATION
CPT-1	CARPET	LIVING ROOM		
PT-1	PAINT	INTERIOR WALLS		
VCT-1	VINYL COMPOSITION TILE	BATHROOM		
WB-1	WOOD BASE	INTERIOR WALLS		

Door Schedule								
NO.	ROOM NAME	SIZE	TYPE	DOOR MATERIAL	DOOR FINISH	FRAME MATERIAL	FRAME FINISH	HARDWARE TYPE
1A	LIVING ROOM	3'-0"x6'-8"	A	EXISTING	-	-	-	ENTRY
1B	BATHROOM	3'-0"x6'-8"	B	MASONITE	PAINT	WOOD	PAINT	PRIVACY
1C	CLOSET	2'-0"x6'-8"	C	MASONITE	PAINT	WOOD	PAINT	PASSAGE

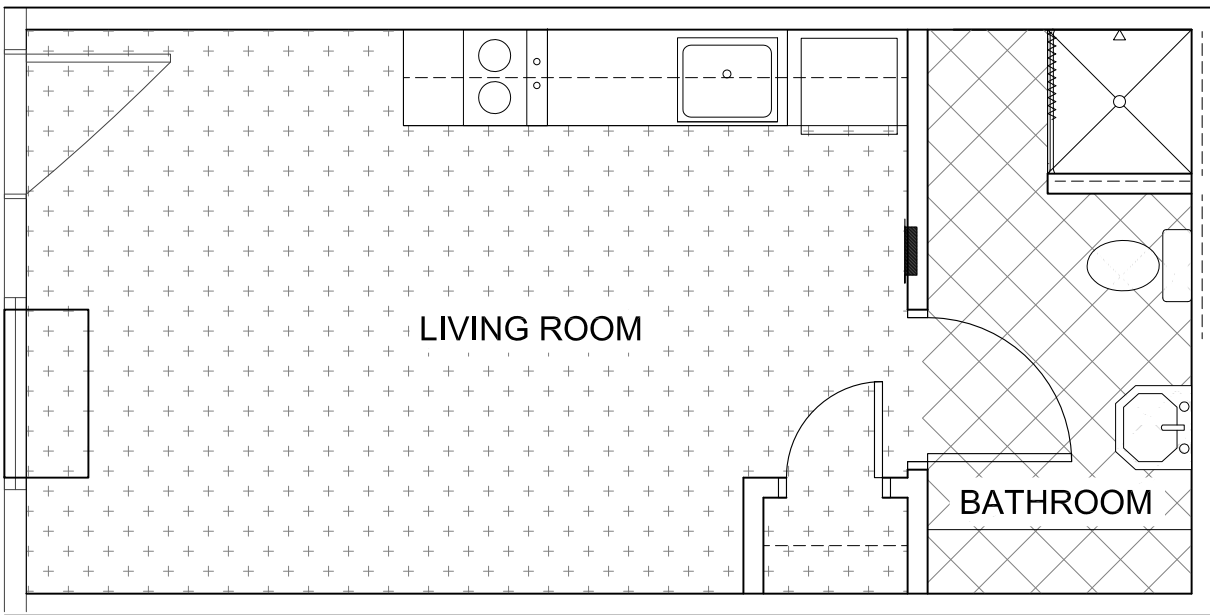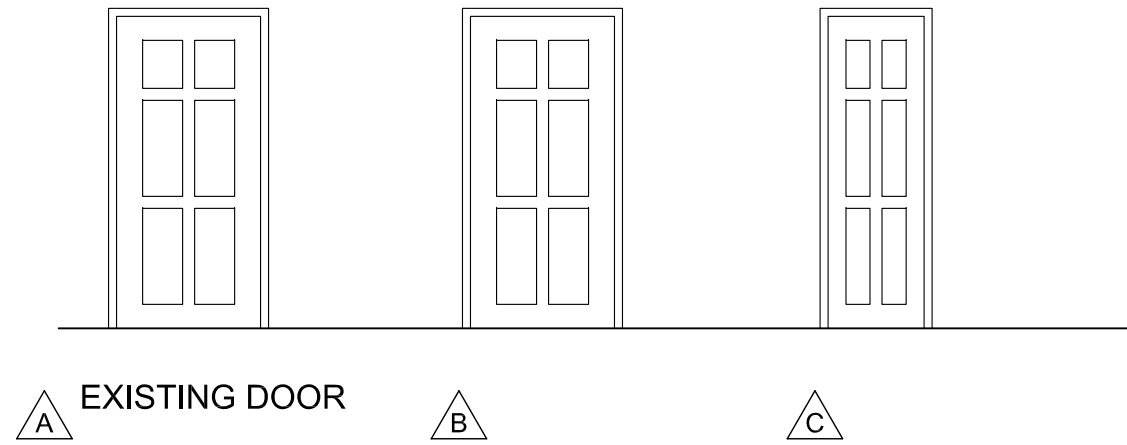

A1 Typical Room Finish Plan
Scale: 1/4"=1'-0"

Room Finish Schedule					
ROOM NAME	FLOOR	BASE	WALLS	CEILING	HEIGHT
LIVING ROOM	F1	B1	W1	C1	±9'-0"
BATHROOM	F2	B1	W1	C1	±9'-0"
FLOOR: F1 CARPET CPT-1 F2 VCT VCT-1 BASE: B1 WOOD BASE WB-1 WALLS: W1 PAINTED GPDW PT-1 CEILING: C1 GPDW CARPET CPT-1 VCT VCT-1					

REVISIONS	BY

These drawings are the property of W. Alan Kenson & Associates P.C., and may not be reproduced in any way without the written consent of W. Alan Kenson & Associates, P.C.

PRELIMINARY NOT FOR CONSTRUCTION

W. Alan Kenson & Associates, P.C.
P 928-443-5812
F 928-443-5815
email: waka@cableone.net
www.kenson-associates.com

ARCHITECTURE & PLANNING

DRAWING: Preliminary Door Schedule, Materials Schedule and Room Finish Plan

PROJECT: Renovation Project for Beck Legacy Group
1040 Whipple Street Building 200
Prescott, AZ 86305


APN: 115-09-008D

DRAWN BY L.O.
CHECKED BY W.A.K.
DATE April 5th, 2018
JOB NO. 711
SHEET

Apr 05, 2018 - 2:48pm


Toilet Accessory Schedule					
FIXTURE	MANUFACTURER	MODEL	COLOR	CONTACT	COMMENTS
GRAB BARS 36" & 42" (TOILET) 18" VERTICAL	GAMCO	150Sx36, 150Sx42 150Sx18		WWW.GAMCOUSA.COM	
SHOWER STALL	AQUATIC	AX3636SH-WH	WHITE	WWW.AQUATICBATH.COM	
HANDICAP ACCESSIBLE SHOWER	AQUATIC	1603BFSD	WHITE	WWW.AQUATICBATH.COM	WITH GRAB BARS, FOLD-UP SEAT, HANDHELD SHOWER ASSEMBLY AND SOAP DISH
TOILET	KOHLER	K-76407-0	WHITE	WWW.KOHLER.COM	COMFORT HEIGHT, ROUND BOWL
LAVATORY	KOHLER	K2032-0	WHITE	WWW.KOHLER.COM	
MIRROR	GAMCO	C18x36		WWW.GAMCO.COM	
SHOWER TRIM	KOHLER	K-TS98008-4		WWW.KOHLER.COM	SHOWER HEAD AND SINGLE LEVER HANDLE
LAVATORY FAUCET	KOHLER	K-15241-4DRA		WWW.KOHLER.COM	
SHOWER CURTAIN WITH GROMETS	GAMCO	100SC 42x72	WHITE	WWW.GAMCOUSA.COM	
SHOWER HOOKS	GAMCO	100CH		WWW.GAMCOUSA.COM	
SHOWER ROD	GAMCO	SR SERIES C		WWW.GAMCOUSA.COM	

NOTE: ALL ITEMS MAY BE SUBSTITUTED WITH EQUAL OR BETTER QUALITY FIXTURES.

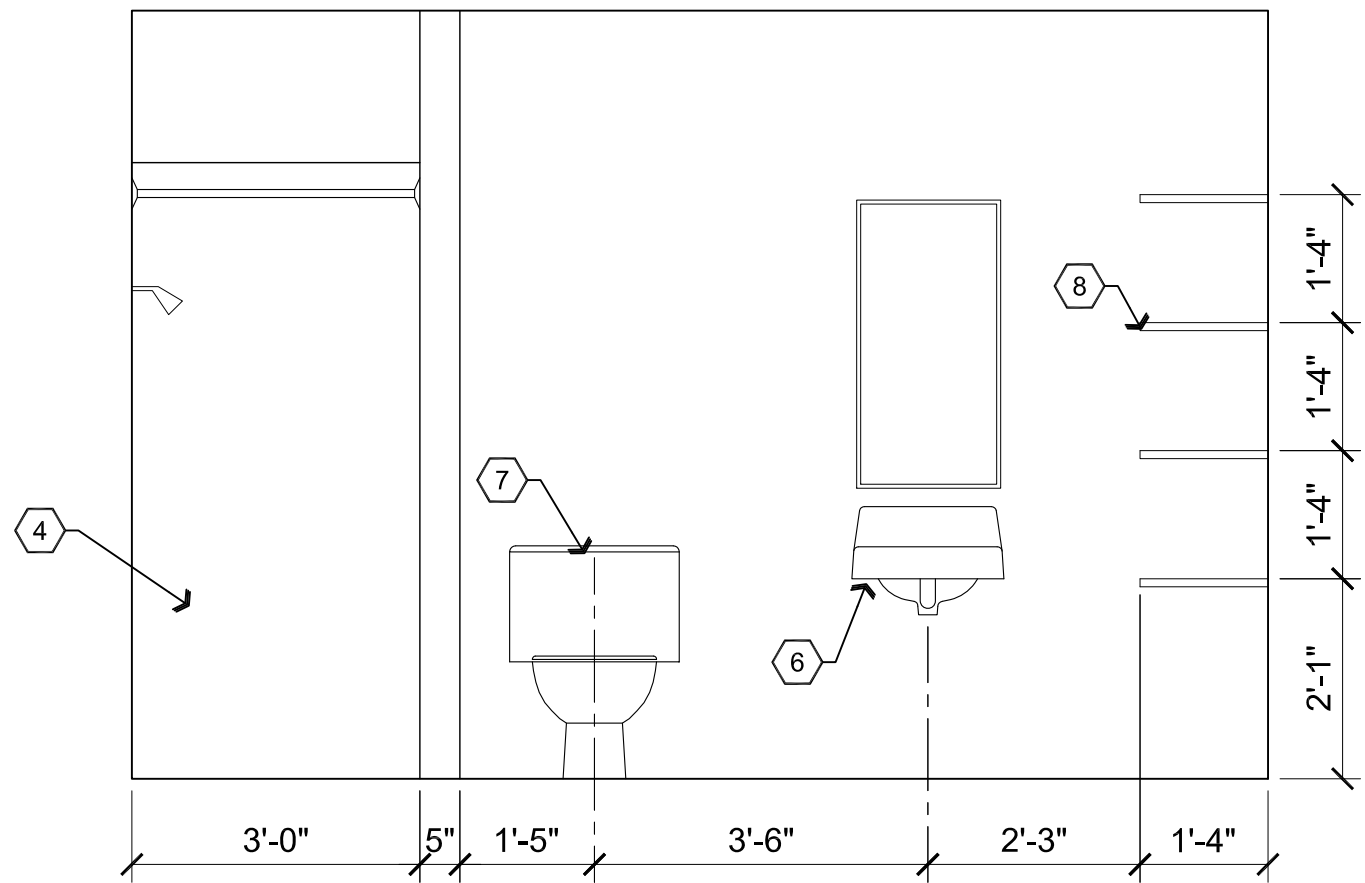

A2 Bathroom Elevation


Scale: 1/2"=1'-0"

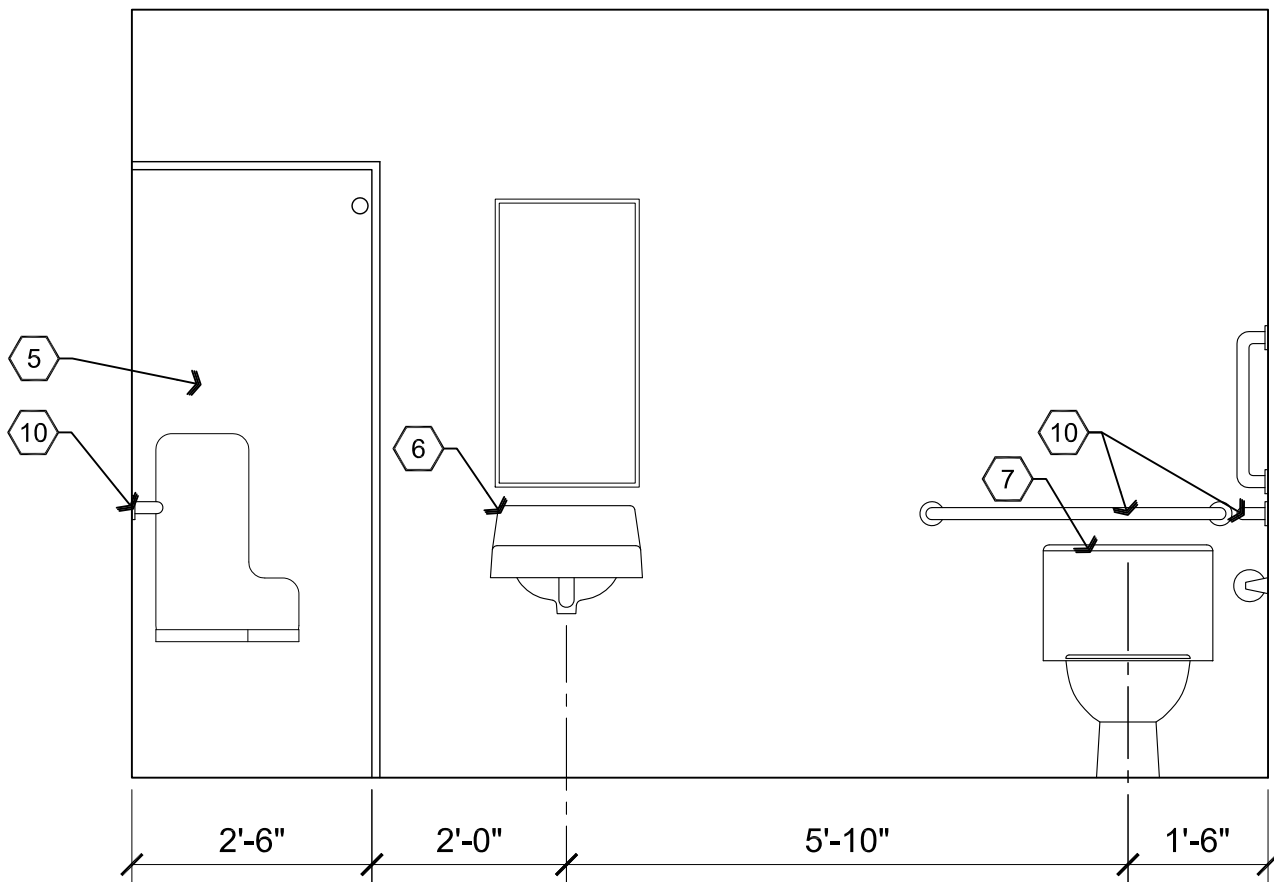

A1 Bathroom Elevation (ADA Compliant)


Scale: 1/2"=1'-0"

NOTE: SOME UNIT PLANS ARE MIRRORED

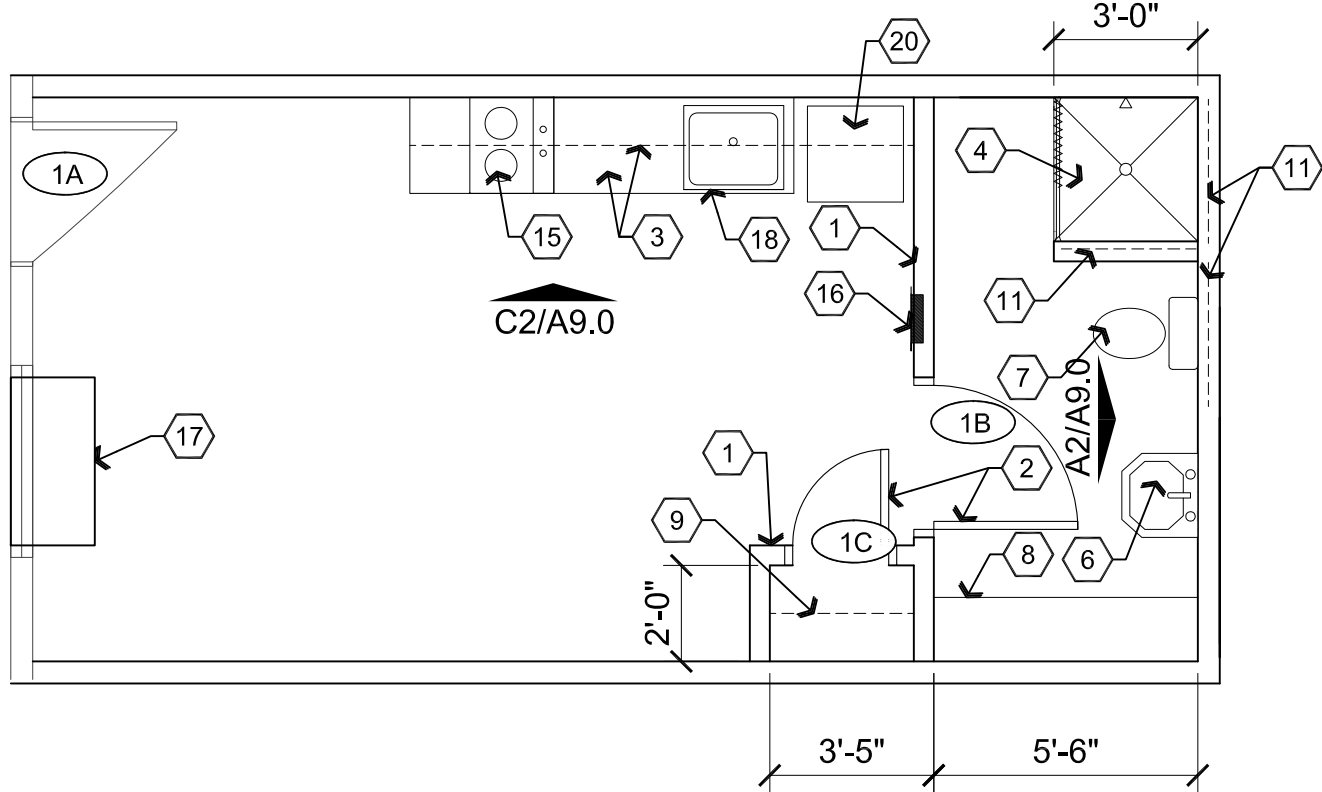

B2 Studio Type 'B' Plan

Scale: 1/4"=1'-0"

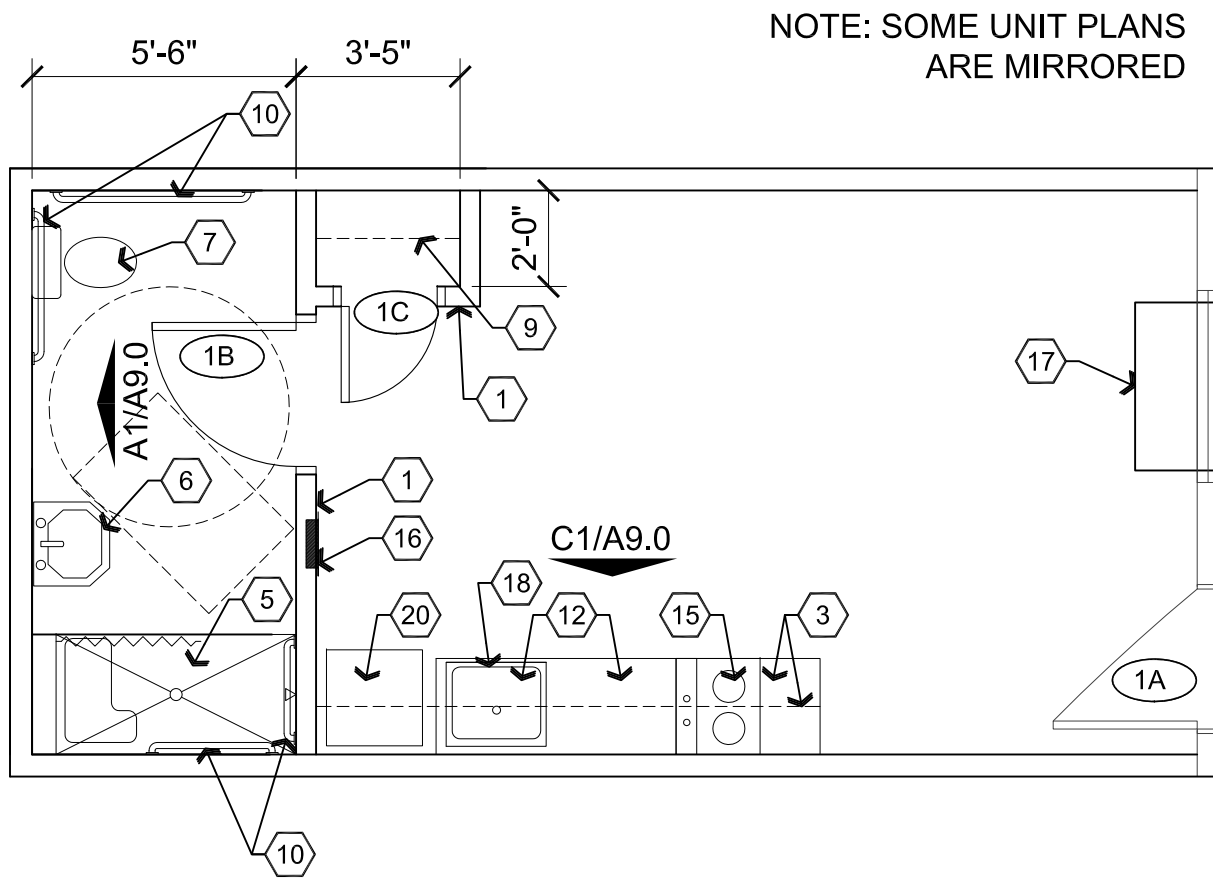

B1 Studio Type 'A' Plan (ADA Compliant)


Scale: 1/4"=1'-0"

Descriptive Keynotes

1. PROVIDE WALL, TYPICAL, REFER TO WALL TYPES.
2. PROVIDE NEW DOOR AND FRAME, REFER TO DOOR SCHEDULE, TYPICAL.
3. PROVIDE UPPER AND LOWER CABINETRY, TYPICAL.
4. PROVIDE 36"x36" PRE-FAB FIBERGLASS SHOWER ENCLOSURE WITH SHOWER CURTAIN, TYPICAL, REFER TO TOILET ACCESSORY SCHEDULE AND PLUMBING PLANS.
5. PROVIDE HANDICAP ACCESSIBLE ROLL-IN SHOWER, REFER TO TOILET ACCESSORY SCHEDULE AND PLUMBING PLANS.
6. PROVIDE LAVATORY, TYPICAL, REFER TO TOILET ACCESSORY SCHEDULE AND PLUMBING PLANS.
7. PROVIDE TOILET, TYPICAL, REFER TO TOILET ACCESSORY SCHEDULE AND PLUMBING PLANS.
8. PROVIDE SHELVES, REFER TO INTERIOR ELEVATIONS.
9. PROVIDE CLOSET ROD AND SHELF.
10. PROVIDE GRAB BARS, REFER TOILET ACCESSORY SCHEDULE.
11. PROVIDE BLOCKING IN WALLS FOR FUTURE GRAB BARS IN FIRST FLOOR UNITS ONLY.
12. PROVIDE OPEN SPACE UNDER COUNTERTOP FOR ACCESSIBLE KNEE SPACE FOR PREP AREA AND AT SINK.
13. PROVIDE MICROWAVE SHELF.
14. PROVIDE PLASTIC LAMINATE COUNTERTOP WITH 4" BACKSPLASH.
15. 2 BURNER ELECTRIC COOKTOP AS MANUFACTURED BY SUMMIT, MODEL #CR2110WH PROVIDED BY OWNER.
16. PROVIDE RECESSED ELECTRICAL PANEL, REFER TO ELECTRICAL PLANS.
17. PROVIDE PTAC HVAC UNIT, REFER TO MECHANICAL PLANS.
18. PROVIDE STAINLESS STEEL, SINGLE COMPARTMENT SINK WITH FAUCET AND DISPOSAL, REFER TO PLUMBING PLANS.
19. MICROWAVE BY OWNER
20. REFRIGERATOR BY OWNER.


Unit Types and Quantities

	STUDIO TYPE 'A' ACCESSIBLE	STUDIO TYPE 'B' ADAPTABLE	STUDIO TYPE 'B' NON ADAPTABLE	LARGE STUDIO ADAPTABLE	LARGE STUDIO NON ADAPTABLE
FIRST FLOOR	2	18	0	2	0
SECOND FLOOR	0	0	20	0	2

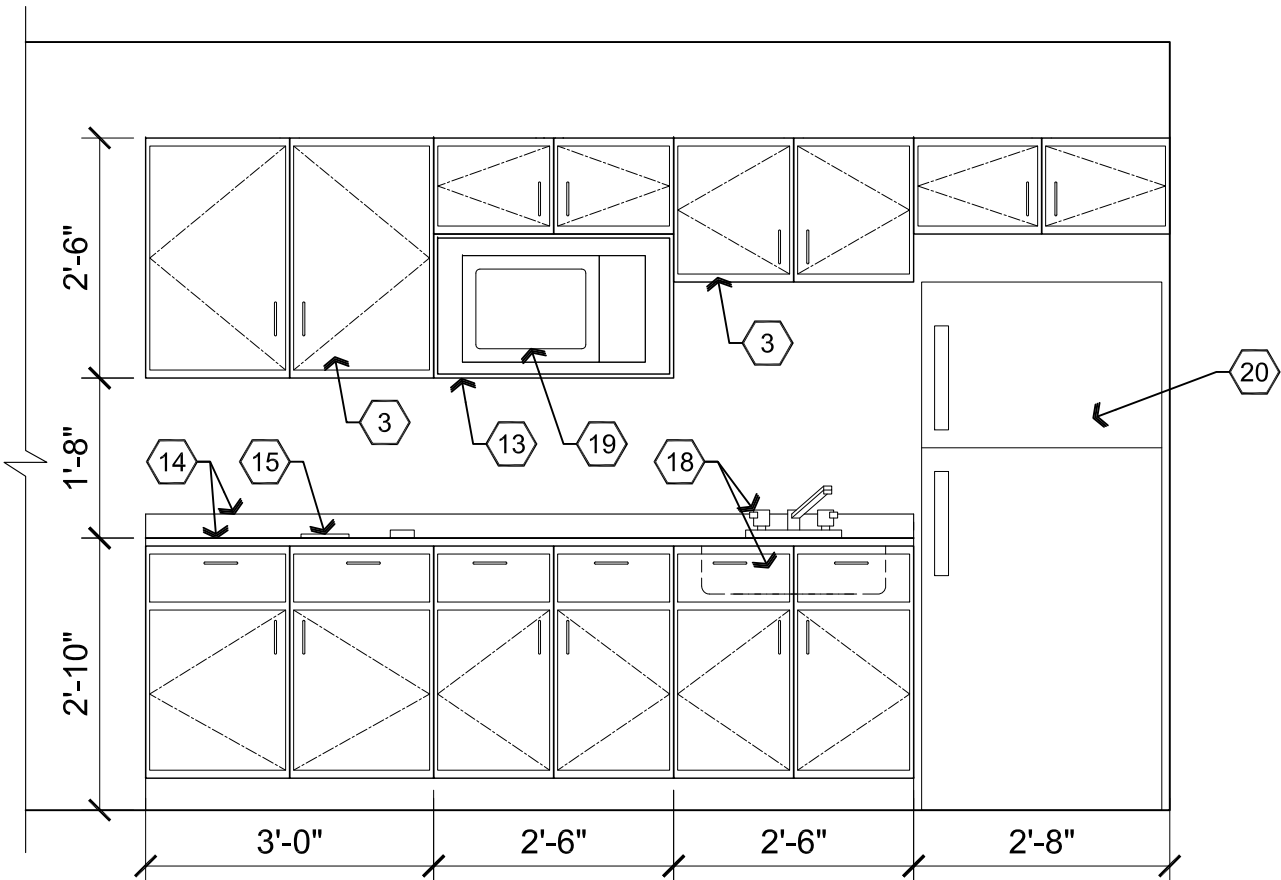

C2 Kitchen Elevation

Scale: 1/2"=1'-0"

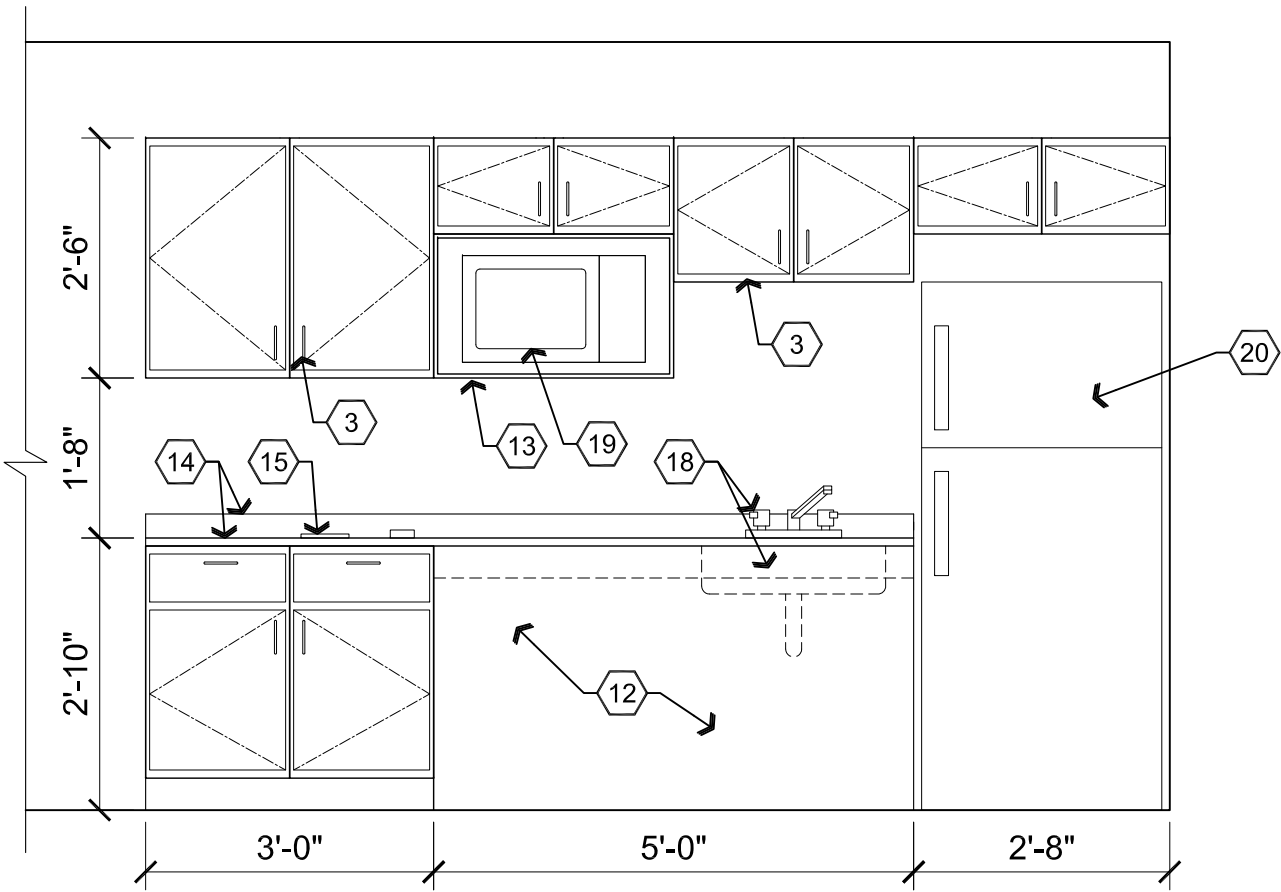

C1 Kitchen Elevation (ADA Compliant)

Scale: 1/2"=1'-0"

REVISIONS	BY

These drawings are the property of W. Alan Kenson & Associates P.C., and may not be reproduced in any way without the written consent of W. Alan Kenson & Associates, P.C.

PRELIMINARY NOT FOR CONSTRUCTION

W. Alan Kenson & Associates, P.C.



P 928-443-5812
F 928-443-5815
email: waka@cableone.net
www.kenson-associates.com

P.O. Box 11593
Prescott, AZ 86304

ARCHITECTURE & PLANNING

DRAWING: Preliminary Interior Elevations

PROJECT: Renovation Project for Beck Legacy Group
1040 Whipple Street Building 200
Prescott, AZ 86305

APN: 115-09-008D

DRAWN BY L.O.

CHECKED BY W.A.K.

DATE April 5th, 2018

JOB NO. 711

SHEET

A9.0

A1 Enlarged Electrical Plan
Scale: 1/4"=1'-0"
Plan North

- Descriptive Keynotes**
1. EXISTING 1200 AMP 120/208 THREE PHASE SERVICE ENTRANCE SECTION.
 2. EXISTING ELECTRIC PANEL.
 3. EXISTING FIRE ALARM PANEL.
 4. EXISTING FIRE RISER.
 5. PROVIDE ELECTRICAL PANEL.
 6. TWO BURNER ELECTRICAL COOKTOP BY OWNER.
 7. REFRIGERATOR BY OTHERS.
 8. GARBAGE DISPOSAL, REFER TO PLUMBING PLANS.
 9. PTAC UNIT, REFER TO MECHANICAL PLANS.

A2 Enlarged Plan, Typical
Scale: 1/4"=1'-0"

B1 1st Floor Electrical Plan B200
Scale: 1/8"=1'-0"
Plan North

C1 2nd Floor Electrical Plan B200
Scale: 1/8"=1'-0"
Plan North

Legend	
	ELECTRICAL PANEL
	DISCONNECT
	JUNCTION BOX
	DUPLEX RECEPTICLE, AT 18" A.F.F.
	DUPLEX RECEPTICLE ABOVE COUNTER OR HEIGHT AS INDICATED
	SWITCH, SINGLE POLE AT 48" A.F.F.
	LIGHT FIXTURE, FLUORESCENT
	FLUSH MOUNT, LOW PROFILE, LED
	VANITY LIGHT FIXTURE, WALL MOUNTED
	CABLE TELEVISION OUTLET AT 18" A.F.F.
	SMOKE DETECTOR / FIRE ALARM
	RECESSED WALL MOUNTED EXHAUST FAN
	12" LED DIRECT WIRE UNDER CABINET LIGHT

NOTE: REPLACE EXISTING EXTERIOR LIGHTING WITH CODE COMPLIANT LED LIGHTS.

REVISIONS	BY

These drawings are the property of W. Alan Kenson & Associates P.C., and may not be reproduced in any way without the written consent of W. Alan Kenson & Associates, P.C.

PRELIMINARY NOT FOR CONSTRUCTION

W. Alan Kenson & Associates, P.C.

P 928-443-5812
F 928-443-5815
email: waka@cableone.net
www.kenson-associates.com

P.O. Box 11593
Prescott, AZ 86304

ARCHITECTURE & PLANNING

DRAWING: Preliminary Electrical Plans

PROJECT: Renovation Project for Beck Legacy Group
1040 Whipple Street Building 200
Prescott, AZ 86305

APN: 115-09-008D

DRAWN BY L.O.
CHECKED BY W.A.K.
DATE April 5th, 2018
JOB NO. 711
SHEET

E1.0